


EXISTING SURVEY LAYOUT PLAN OF PHC HOSPITAL IN IBRAHIM NAGAR VILLAGE, CHINNAKODUR MANDAL, MEDAK DIST, TELANGANA STATE.

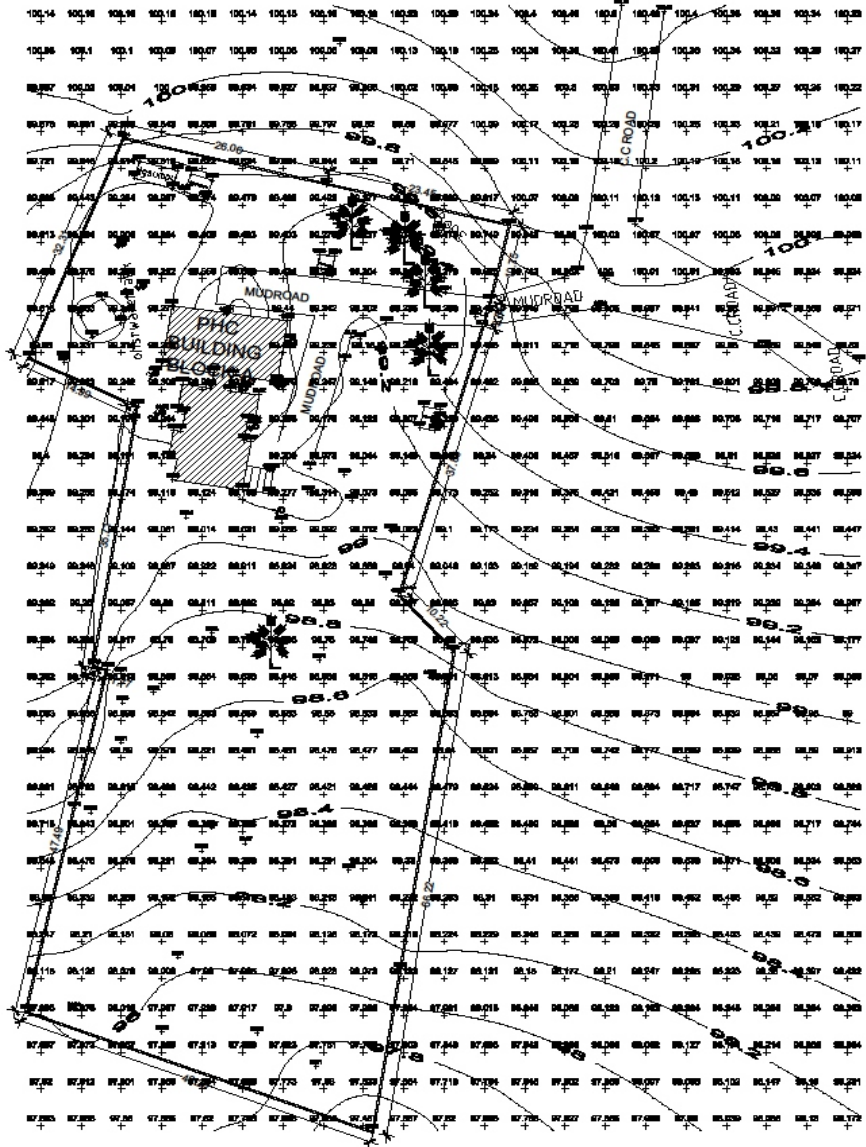


1. CONTRACTOR TO CHECK AND VERIFY ALL DIMENSIONS BEFORE EXECUTION OF THE WORK.
 2. FIGURED DIMENSIONS SHALL BE FOLLOWED.
 3. ALL DIMENSIONS GIVEN ARE IN MILLIMETERS UNLESS OTHERWISE SPECIFIED.

AREA STATEMENT:-
 SITE AREA = 1.34 ACRES, 58156 SQ M
 SURVEYED PHC BLOCK AREA
 GROUND FLOOR BUILT UP AREA = 2875 SQ M

CLIENT:
 TELANGANA STATE MEDICAL SERVICES AND INFRASTRUCTURE DEVELOPMENT CORPORATION

DRAWING TITLE:
 EXISTING SITE PLAN

SCALE	NTS
DATE	NOV 2018
DRAWN	ASP
CHECKED	VRM

 

LEGEND


ROAD	—————
COMPOUND WALL	—————
MAN HOLE	MH □ MH ○
ELECTRIC POLE	EP ●
TREE	▲

PROJECT TITLE:
 PREPARATION OF SURVEY MAP AND ANNET MAPPING FOR PHC AT IBRAHIM NAGAR (V) CHINNAKODUR MANDAL, MEDAK DISTRICT

S. KUMAR
 ARCHITECTS & ENGINEERS
 13/2c-24-74/7, 1st Floor, Ameer Nagar, Sec-10, Gurgaon, Haryana-122002, India
 T: +91-122-4007333; F: +91-122-4007333; Email: s.kumar.architects@rediffmail.com; web: http://www.s.kumararchitects.com


TITLE:
 EXISTING SURVEY LAYOUT PLAN OF PHC HOSPITAL IN IBRAHIM NAGAR VILLAGE, CHINNAKODUR MANDAL, MEDAK DIST, TELANGANA STATE.

SK-REG-PHC-LP-01

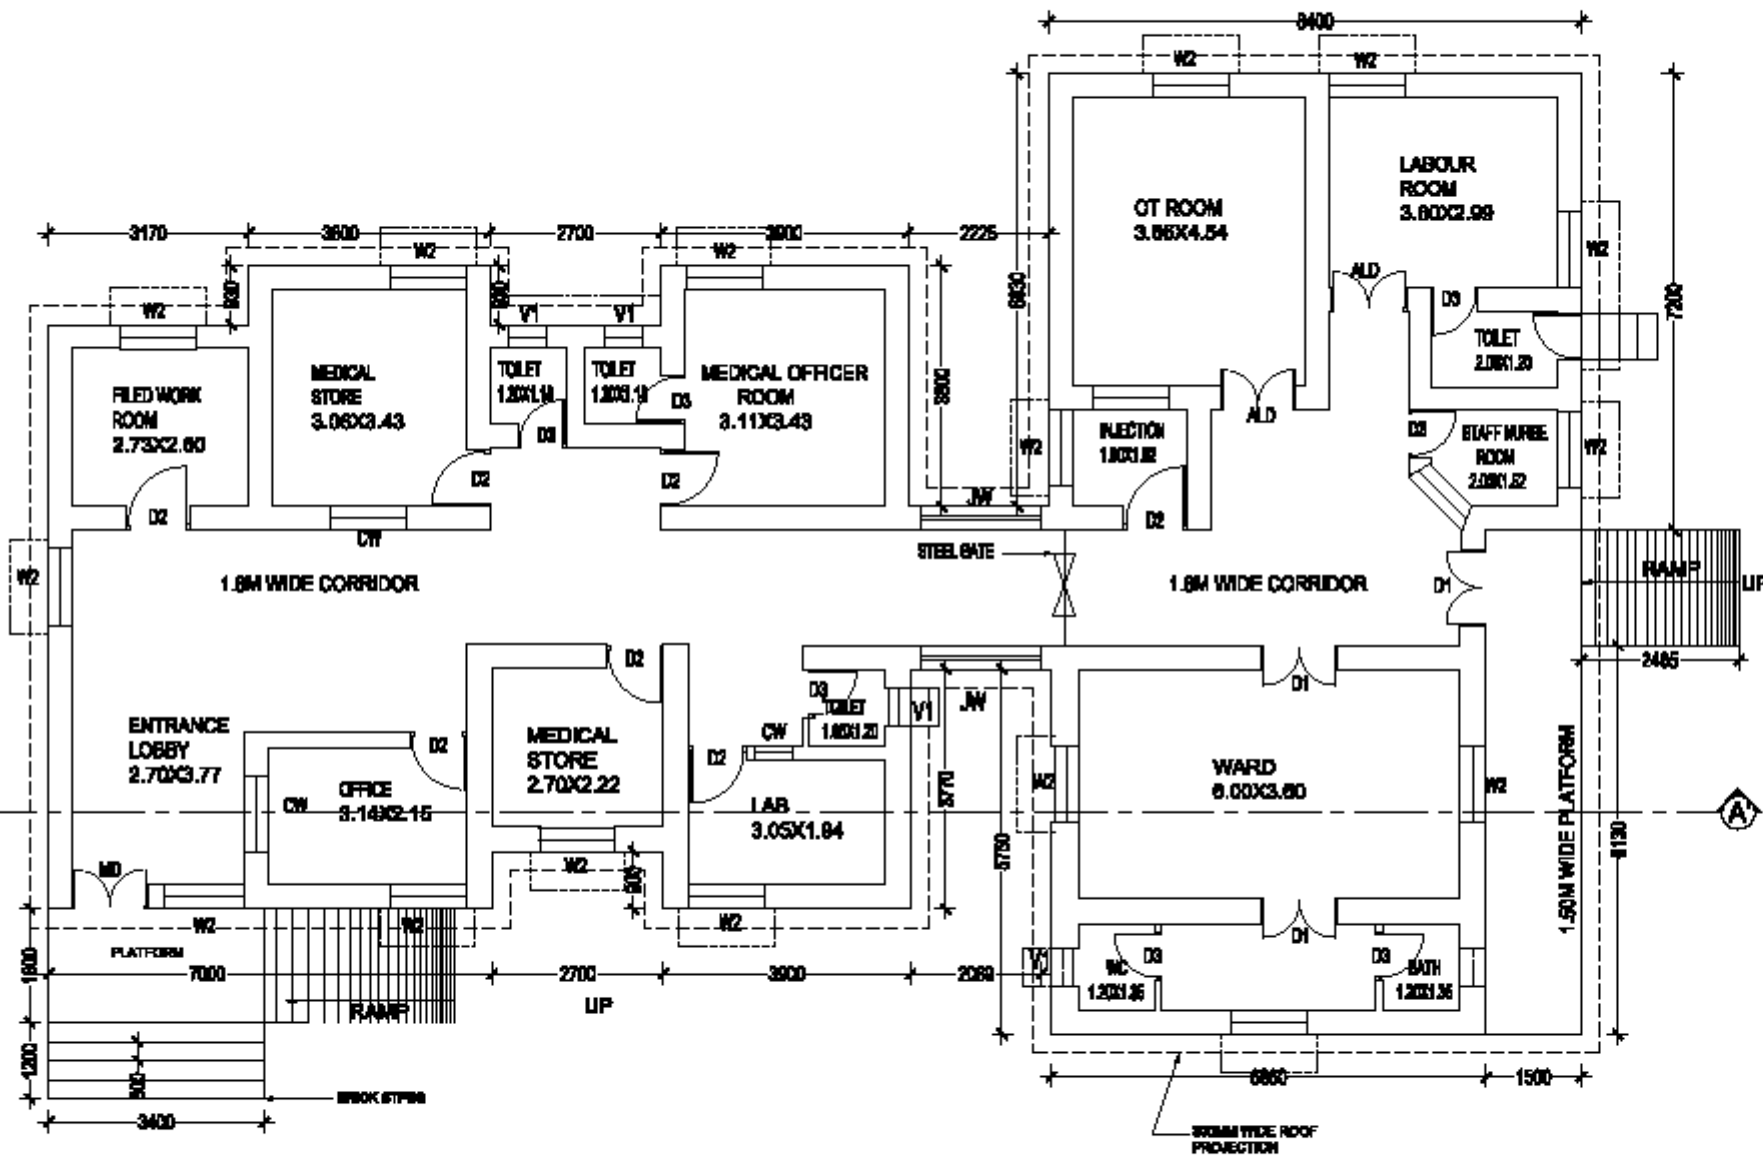

**GROUND FLOOR PLAN
PHC (BLOCK-A)**

NOTE:
 1. CONTRACTOR TO CHECK AND VERIFY ALL DIMENSIONS BEFORE EXECUTION OF THE WORK.
 2. ALL DIMENSIONS SHALL BE FOLLOWED.
 3. ALL DIMENSIONS GIVEN ARE IN MILLIMETERS UNLESS OTHERWISE SPECIFIED.

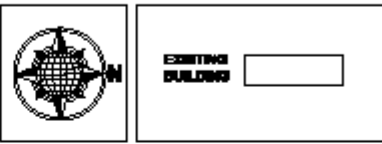

DESCRIPTION OF THE EXISTING BUILDING	
STRUCTURE	RED BRICK STRUCTURE & CONCRETE STRUCTURE
BUILT UP AREA	GROUND FLOOR - 3671 SQ M
FLOORING OF FLOOR	GRAVEL FLOOR
NUMBER OF FLOOR STRUCTURE/FLOORING	3/2
ROOF TYPE	ROOFRAISE
YEAR OF CONSTRUCTION	
ASSESSMENT	STABILITY OR SOLENOY RECOMMENDED FOR WITH ST. 0.00

SCHEDULE OF OPENINGS		
TYPE	DESCRIPTION	SIZE
MD	MAIN DOOR	1800 X 2000
ALD	ALUMINIUM DOOR	1800 X 2000
D1	DOUBLE SHUTTER DOOR	1800 X 1800
D2	SINGLE SHUTTER DOOR	900 X 2000
D3	SHRIMP SHUTTER DOOR	750 X 2100
W1	WINDOW	1800 X 1800
W2	WINDOW	1800 X 1800
JW	JALI WINDOW	1800 X 1800
CW	COLUMNER WINDOW	1200 X 1300
V1	VENTILATOR	600 X 800

AREA STATEMENT:
 PROPOSED GROUND FLOOR BUILT UP AREA = 3671 SQ M
 PORTICO AREA WTS = 200 SQ M
 TOTAL AREA = 3871 SQ M

CLIENT: TELANGANA STATE MEDICAL SERVICES AND INFRASTRUCTURE DEVELOPMENT CORPORATION


PROJECT TITLE:
 PREPARATION OF SURVEY MAP AND ASSET MAPPING FOR PHC AT IDRAHARI NAGAR, CHENNAIDUR MANDAL, MEDAK DISTRICT

TITLE:
 EXISTING SURVEY LAYOUT PLAN OF PRIMARY HEALTH CENTER IN IDRAHARI NAGAR, CHENNAIDUR MANDAL, MEDAK DIST, TELANGANA STATE.

GROUND FLOOR PLAN PHC BLOCK-A	
SCALE	1/10
DATE	OCT 2019
DRAWN	ASP
CHECKED	YVW

CONSULTANT:

S. KUMAR
 ARCHITECTS & ENGINEERS
 H. No. 9-9-7446, 1st Floor, ADRA Medical Lane,
 Sitaram Nagar, Ramachandrapuram, Hyderabad - 500013,
 T. S. Ph. No: 040-87324000; 040-87324001
 Email: s.kumar.architectsengineers@gmail.com
 web: http://s.kumararchitects.com/works

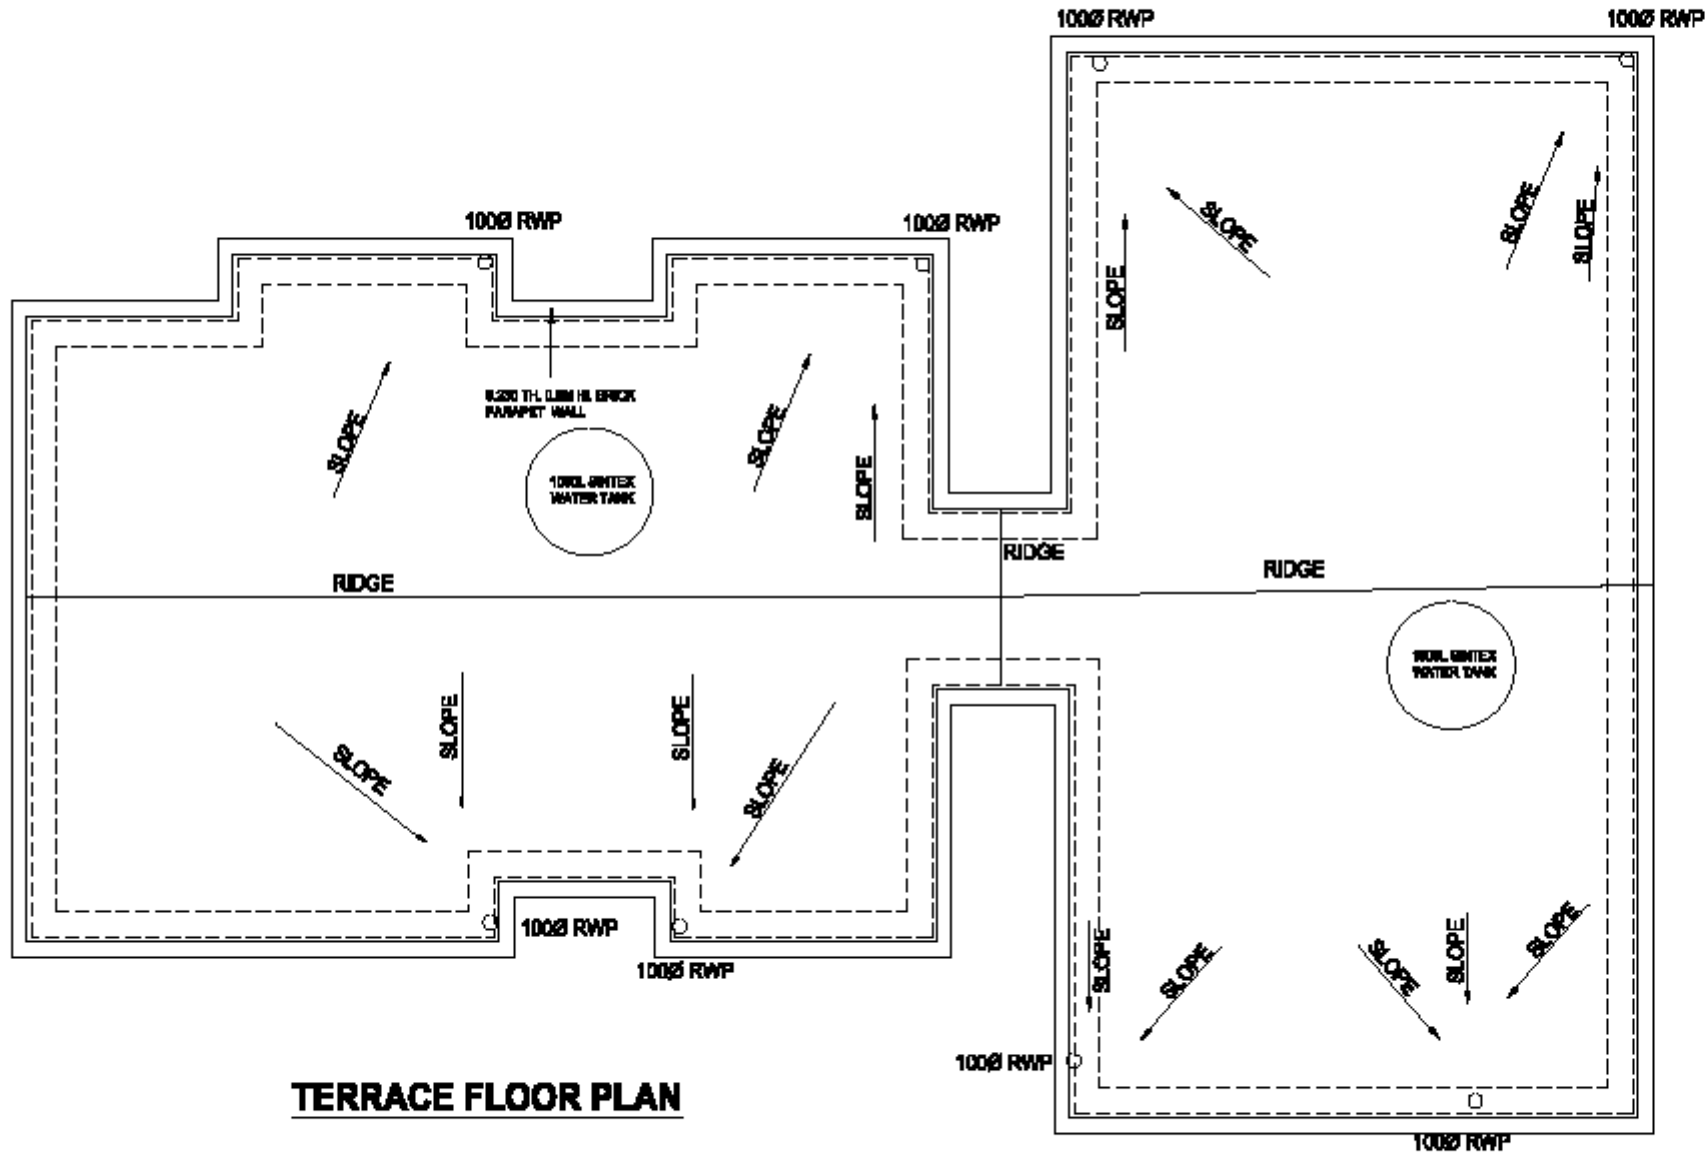

TERRACE FLOOR PLAN

NOTE :
 1. CONTRACTOR TO CHECK AND VERIFY ALL DIMENSIONS BEFORE EXECUTION OF THE WORK.
 2. PROVIDED DIMENSIONS SHALL BE FOLLOWED.
 3. ALL DIMENSIONS GIVEN ARE IN MILLIMETERS UNLESS OTHERWISE SPECIFIED.


EXISTING BUILDING

CLIENT: TELANGANA STATE MEDICAL SERVICES AND INFRASTRUCTURE DEVELOPMENT CORPORATION

PROJECT TITLE:
 PREPARATION OF SURVEY MAP AND ASSET MAPPING FOR PHC AT IBRAHIM NAGAR, CHIBIKODUR, MANDAL, NEDAM, DISTRICT

TITLE:
 EXISTING SURVEY LAYOUT PLAN OF PRIMARY HEALTH CENTER IN IBRAHIM NAGAR, CHIBIKODUR, MANDAL, NEDAM DIST. TELANGANA STATE.

**TERRACE FLOOR PLAN
 PHC BLOCK-A**

SCALE	DATE
DRAWN	CHECKED
DATE	DATE


CONSULTANT :

S. KUMAR
 ARCHITECTS & ENGINEERS


H. No. 9-9-7446, 1st Floor, ADRA Hospital Lane,
 Srinivas Nagar, Ramachandrapuram, Hyderabad - 500013,
 T. S. Ph. No : 944-87434888; 944888888888;
 Email : s.kumar.architectsengineers@gmail.com
 web : http://s.kumar.architects.com/india

PROJECT ID: SK-DOU-PHC-A-02

NOTE :
 1. CONTRACTOR TO CHECK AND VERIFY ALL DIMENSIONS BEFORE EXECUTION OF THE WORK.
 2. FINISHED DIMENSIONS SHALL BE FOLLOWED.
 3. ALL DIMENSIONS GIVEN ARE IN MILLIMETERS UNLESS OTHERWISE SPECIFIED.

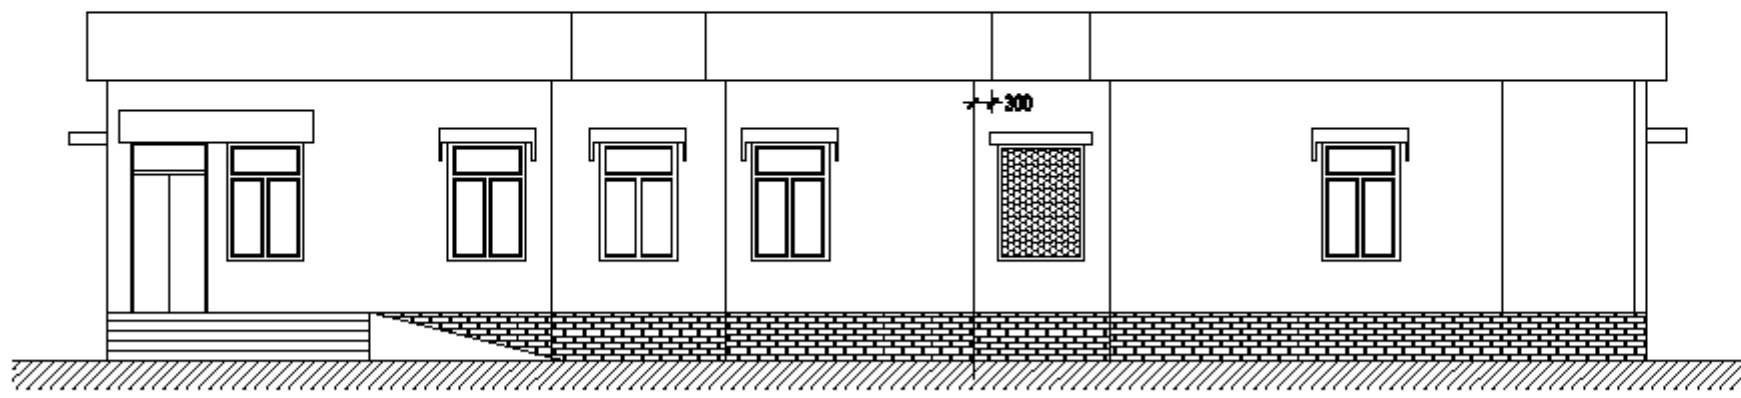

FRONT ELEVATION

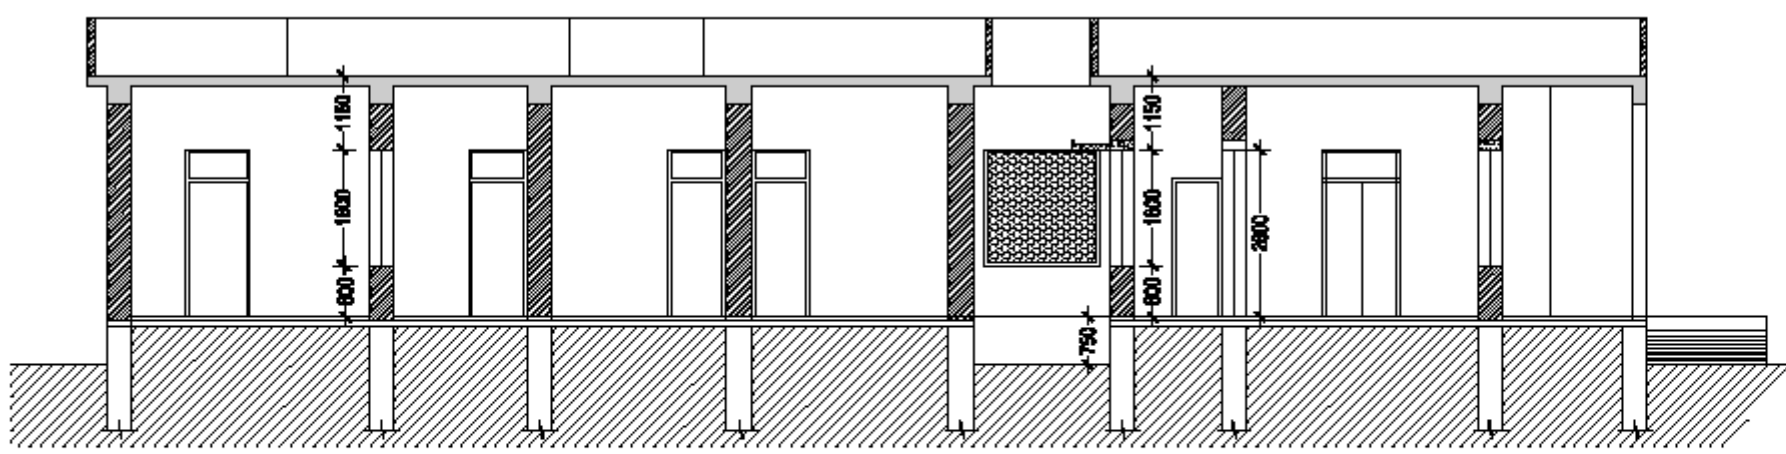

SECTION AT AA'

CLIENT: TELANGANA STATE MEDICAL SERVICES AND INFRASTRUCTURE DEVELOPMENT CORPORATION

PROJECT TITLE: PREPARATION OF SURVEY MAP AND ASSET MAPPING FOR PHC AT BRAHMI NAGAR, CHIRAKOOR MANDAL, MEDAK DISTRICT

TITLE: EXISTING SURVEY LAYOUT PLAN OF PRIMARY HEALTH CENTER IN BRAHMI NAGAR, CHIRAKOOR MANDAL, MEDAK DIST, TELANGANA STATE.

ELEVATION & SECTION
PHC BLOCK-A

SCALE	DATE
DRAWN	CHECKED
DATE	BY
BY	DATE


CONSULTANT:

S. KUMAR
 ARCHITECTS & ENGINEERS


H.No. 9-9-7446, 1st Floor, ADRA Hospital Lane,
 Sitaram Nagar, Ramachandrapuram, Hyderabad - 500113.
 T. & M. No : 040-87322000; 99488882000;
 Email : s.kumar.architectsengineers@gmail.com
 web : http://s.kumar-engineers.com/works

DRWING NO. SK-PAP-PHC-A-03

NOTE :
 1. CONTRACTOR TO CHECK AND VERIFY ALL DIMENSIONS BEFORE EXECUTION OF THE WORK.
 2. FINISHED DIMENSIONS SHALL BE FOLLOWED.
 3. ALL DIMENSIONS GIVEN ARE IN MILLIMETERS UNLESS OTHERWISE SPECIFIED.

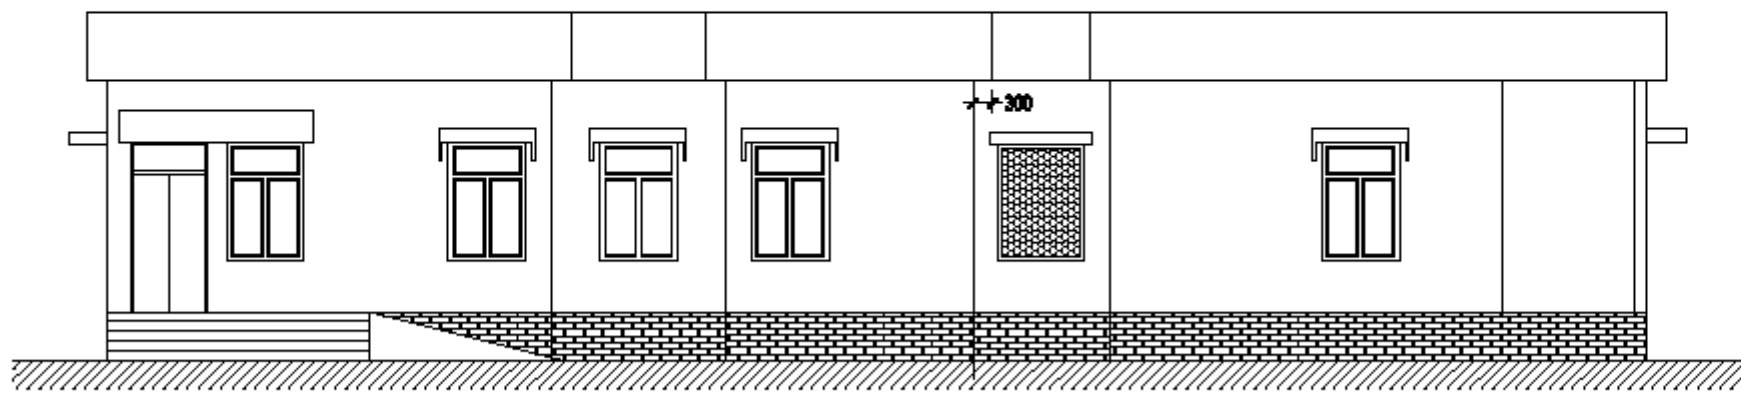

FRONT ELEVATION

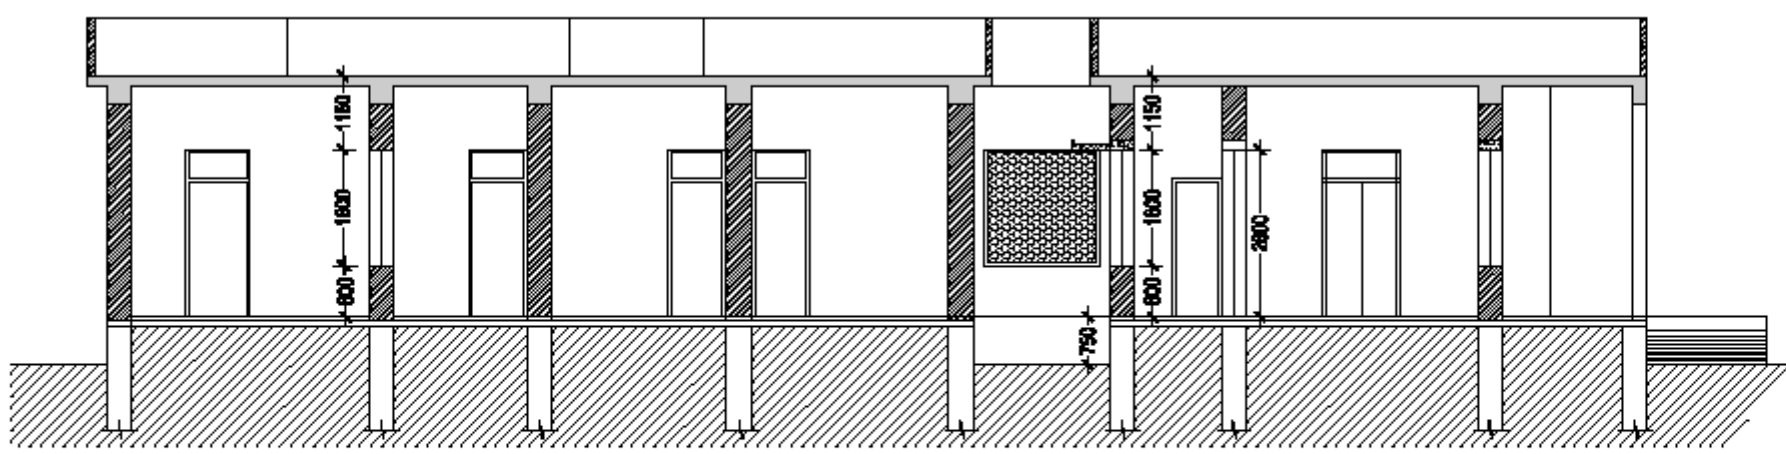

SECTION AT AA'

CLIENT: TELANGANA STATE MEDICAL SERVICES AND INFRASTRUCTURE DEVELOPMENT CORPORATION

PROJECT TITLE: PREPARATION OF SURVEY MAP AND ASSET MAPPING FOR PHC AT BRAHMI NAGAR, CHIRAKOOR MANDAL, MEDAK DISTRICT

TITLE: EXISTING SURVEY LAYOUT PLAN OF PRIMARY HEALTH CENTER IN BRAHMI NAGAR, CHIRAKOOR MANDAL, MEDAK DIST, TELANGANA STATE.

ELEVATION & SECTION
PHC BLOCK-A

SCALE	DATE
DRAWN	CHECKED
DATE	BY


CONSULTANT:

S. KUMAR
 ARCHITECTS & ENGINEERS

H.No. 9-9-7446, 1st Floor, ADRA Hospital Lane,
 Sitaram Nagar, Ramachandrapuram, Hyderabad - 500113.
 T. & M. No : 040-87322000; 99488882000;
 Email : s.kumar.architectsengineers@gmail.com
 web : http://s.kumar-engineers.com/works

DRG. NO. SK-PAP-PHC-A-03

EXISTING SURVEY LAYOUT PLAN OF PHC HOSPITAL IN IBRAHIM NAGAR VILLAGE, CHINNAKODUR MANDAL, MEDAK DIST, TELANGANA STATE.

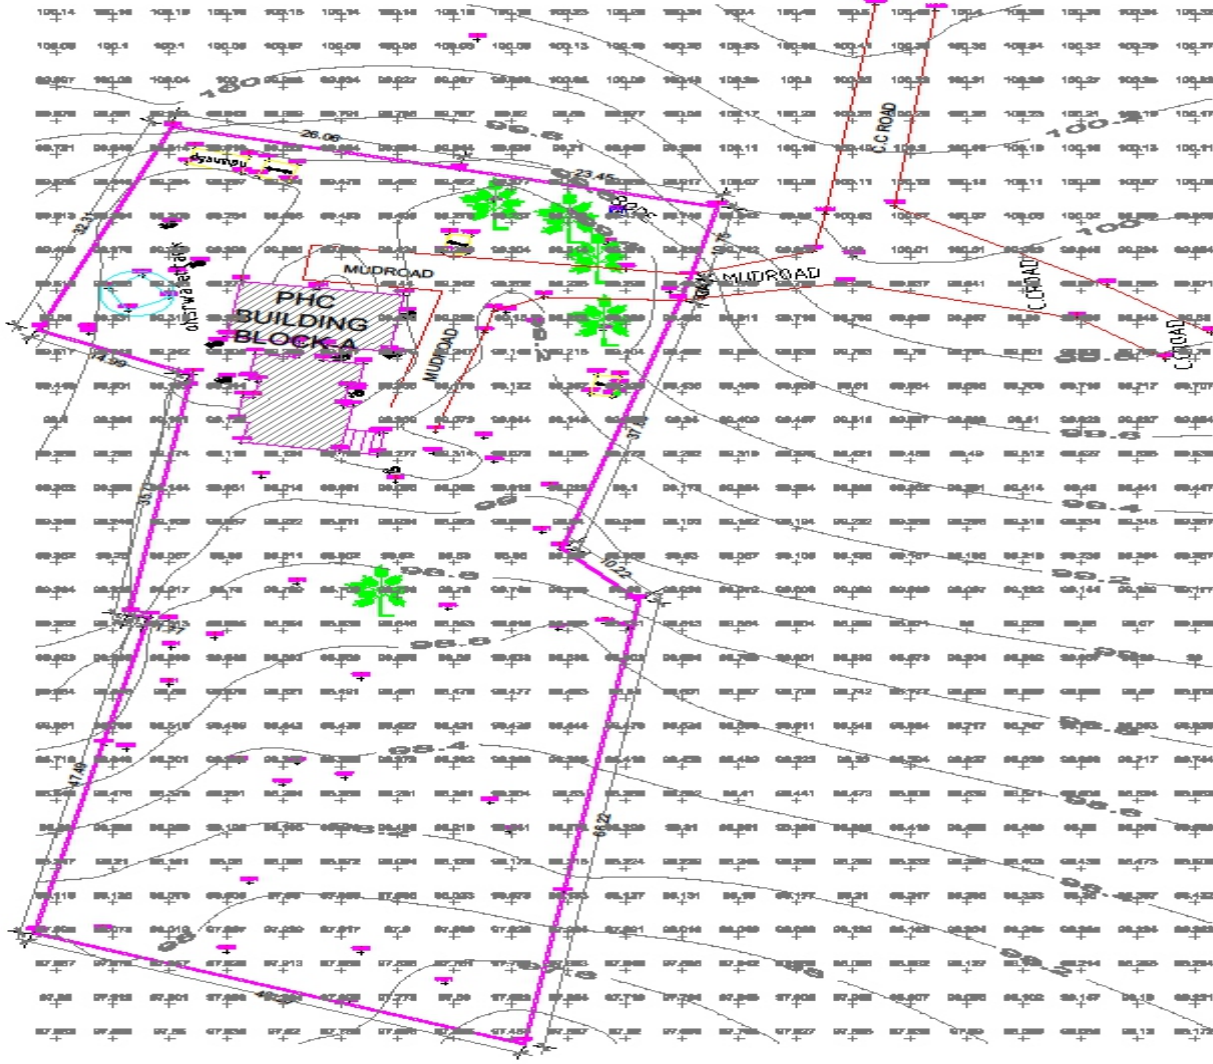

1. CONTRACTOR TO CHECK AND VERIFY ALL DIMENSIONS BEFORE EXECUTION OF THE WORK.
2. FIGURED DIMENSIONS SHALL BE FOLLOWED.
3. ALL DIMENSIONS GIVEN ARE IN MILLIMETERS UNLESS OTHERWISE SPECIFIED.



EDITHA
S.M.S. ENGINEERS

SCALE STATEMENTS:-
 1:24 SCALE, 40x60 CM. S
 DRAWING SIZE: 90x120 CM
 ENCLAVE FLOOR: 100.7000 - 100.7000

LEGEND	
ROAD	
COMPOUND WALL	
MAN HOLE	MH
ELECTRIC POLE	EP
TREE	

CLIENT:
 TELANGANA STATE MEDICAL SERVICES AND INFRASTRUCTURE DEVELOPMENT CORPORATION

PROJECT TITLE:
 PREPARATION OF SURVEY MAP AND ASSET MAPPING FOR PHC AT IBRAHIM NAGAR (V) CHINNAKODUR MANDAL, MEDAK DISTRICT

TITLE:
 EXISTING SURVEY LAYOUT PLAN OF PHC HOSPITAL IN IBRAHIM NAGAR VILLAGE, CHINNAKODUR MANDAL, MEDAK DIST, TELANGANA STATE.

DRAWING TITLE:
 EXISTING SITE PLAN

SCALE	NTS
DATE	NOV 2018
DRAWN	ASP
CHECKED	WPKC

S. KUMAR
 A REGISTERED CIVIL & ELECTRICAL ENGINEER

PL. No: 26-27/2004 of 1998 (Amended) Hyderabad, Telangana State.
 Tel: 011, No 2 262-27022901, +91 9986022224;
 E-mail: skumar_svk@yahoo.com, skumar_svk@gmail.com,
 www.skumar_svk.com, www.skumar_svk.com

SK-REG-PHC-LP-01