


1. DIMENSIONS BEFORE EXECUTION OF THE
 2. FIGURED DIMENSIONS SHALL BE FOLLOWED
 3. ALL DIMENSIONS GIVEN ARE IN MILLIMETER
 UNLESS OTHERWISE SPECIFIED.

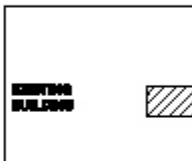

LEGEND

ROAD	
BOUNDARY LINE	
MAN HOLE	MH
BORE WELL	
ELECTRIC POLE	EP
TREE	
NEEM TREE	

AREA STATEMENT:-

NTS AREA = 0.06 ACRES, 1766.13
 EXISTING PHC BUILDING AREA
 GROUND FLOOR BUILT UP AREA = 1624.00 SQM

CLIENT:

TELANGANA STATE MEDICAL SERVICES
 INFRASTRUCTURE DEVELOPMENT
 CORPORATION

PURPOSE TITLE:

PREPARATION OF SURVEY PLAN AND ASSET MAPPING
 AT JARASAGAM (V) MEDAK DISTRICT

TITLE:


EXISTING SURVEY LAYOUT PLAN OF PHC
 HOSPITAL IN JARASAGAM VILLAGE, JARA
 MANDAL, MEDAK DIST, TELANGANA STAT

PHC JARASAGAM
 EXISTING SITE PLAN

SCALE	NTS
DATE	JUNE 20
DRAWN	SANDEEP
CHECKED	VINAY

DESIGNER:

S. KUMAR
 ARCHITECT & ENGINEER
 H. No: 3-0-274/8, 1st Floor, Jagan Hospital &
 Speciality: General, Paediatrics, Gynaecology - 500004
 T. N. No. No: 946-27632604, 4-93-00000000
 E-mail: s.kumar.architect@gmail.com
 Web: s.kumar.architect@gmail.com, 4-93-00000000

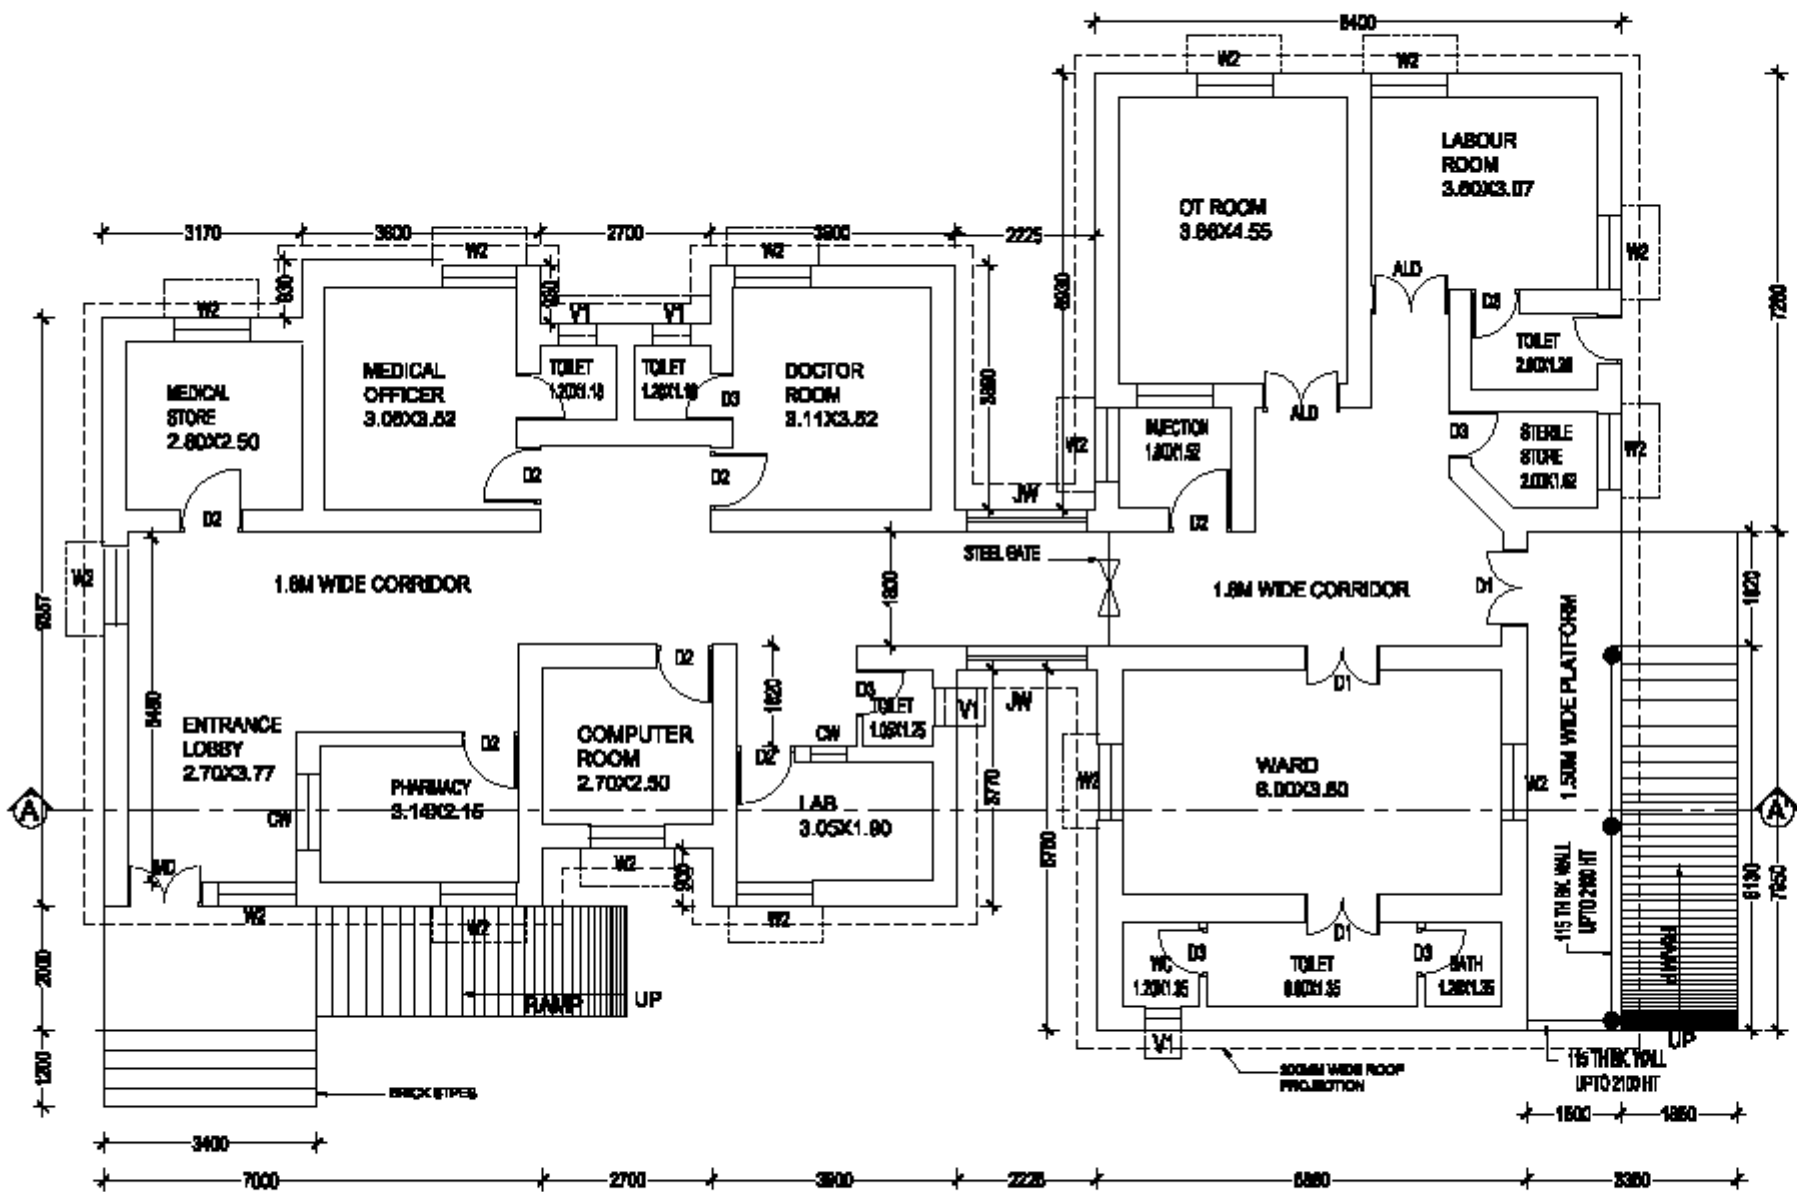

**GROUND FLOOR PLAN
PHC (BLOCK-A)**

AS BUILT DRAWING

NOTE:
 1. CONTRACTOR TO CHECK AND VERIFY ALL DIMENSIONS BEFORE EXECUTION OF THE WORK.
 2. PROVIDED DIMENSIONS SHALL BE FOLLOWED.
 3. ALL DIMENSIONS GIVEN ARE IN MILLIMETERS UNLESS OTHERWISE SPECIFIED.



EXISTING BUILDING	
-------------------	--

DESCRIPTION OF PHE (BLOCK-A)	
STRUCTURE	ROSCIS STRUCTURE EMPER STRUCTURE
BUILT UP AREA	GROUND FLOOR - 3684 SQ.M
FLOORING OF FLOOR	GRAVEL FLOOR
FINISHING OF THE STRUCTURE ON FLOORING	9.50 M
ROOF TYPE	RED BRICK
YEAR OF CONSTRUCTION	
ASSESSMENT	STABILITY BY CODE NOT RECOMMENDED FOR 2ND FLOOR

SCHEDULE OF OPENINGS		
TYPE	DESCRIPTION	SIZE
MD	MAIN DOOR	1800 X 2000
ALD	ALUMINIUM DOOR	1800 X 2000
D1	DOUBLE SHUTTER DOOR	1800 X 1800
D2	SINGLE SHUTTER DOOR	900 X 2000
D3	SHRIMP SHUTTER DOOR	750 X 2100
W1	WINDOW	1800 X 1800
W2	WINDOW	1800 X 1800
JW	JALI WINDOW	1800 X 1800
CW	COLUMNER WINDOW	1200 X 1300
V1	VENTILATOR	600 X 800

AREA STATEMENT:
 EXISTING PHC JHARASANGAM
 GROUND FLOOR BUILT UP AREA = 3684 SQ.M
 PORTED AREA BY PHE = 338 SQ.M
 TOTAL AREA = 3684 SQ.M

CLIENT:
 TELANGANA STATE MEDICAL
 SERVICES AND INFRASTRUCTURE
 DEVELOPMENT CORPORATION

PROJECT TITLE:
 PREPARATION OF SURVEY MAP AND
 ASSET MAPPING FOR PHC AT
 JHARASANGAM(V) MEDAK DISTRICT


TITLE:
 EXISTING SURVEY LAYOUT PLAN OF PRIMARY HEALTH CENTER
 JHARASANGAM VILLAGE, JHARASANGAM MEDICAL, MEDAK DIST,
 TELANGANA STATE.

**PHC JHARASANGAM
GROUND FLOOR PLAN**

SCALE	1/10
DATE	JUN 2016
DRAWN	MDR
CHECKED	YMR

CONSULTANT:
S. KUMAR
 ARCHITECTS & ENGINEERS
 H.No. 3-9-7446, 1st Floor, ADRA Hospital Lane,
 Sitaram Nagar, Ramachandrapuram - 500013,
 T. S. P. No. 64-87324000; +91 83868 8884;
 Email: kumar.architects@rediffmail.com,
 web: http://skumarconsultants.com/area

PROJECT NO. SK-JHA-PHC-A-01

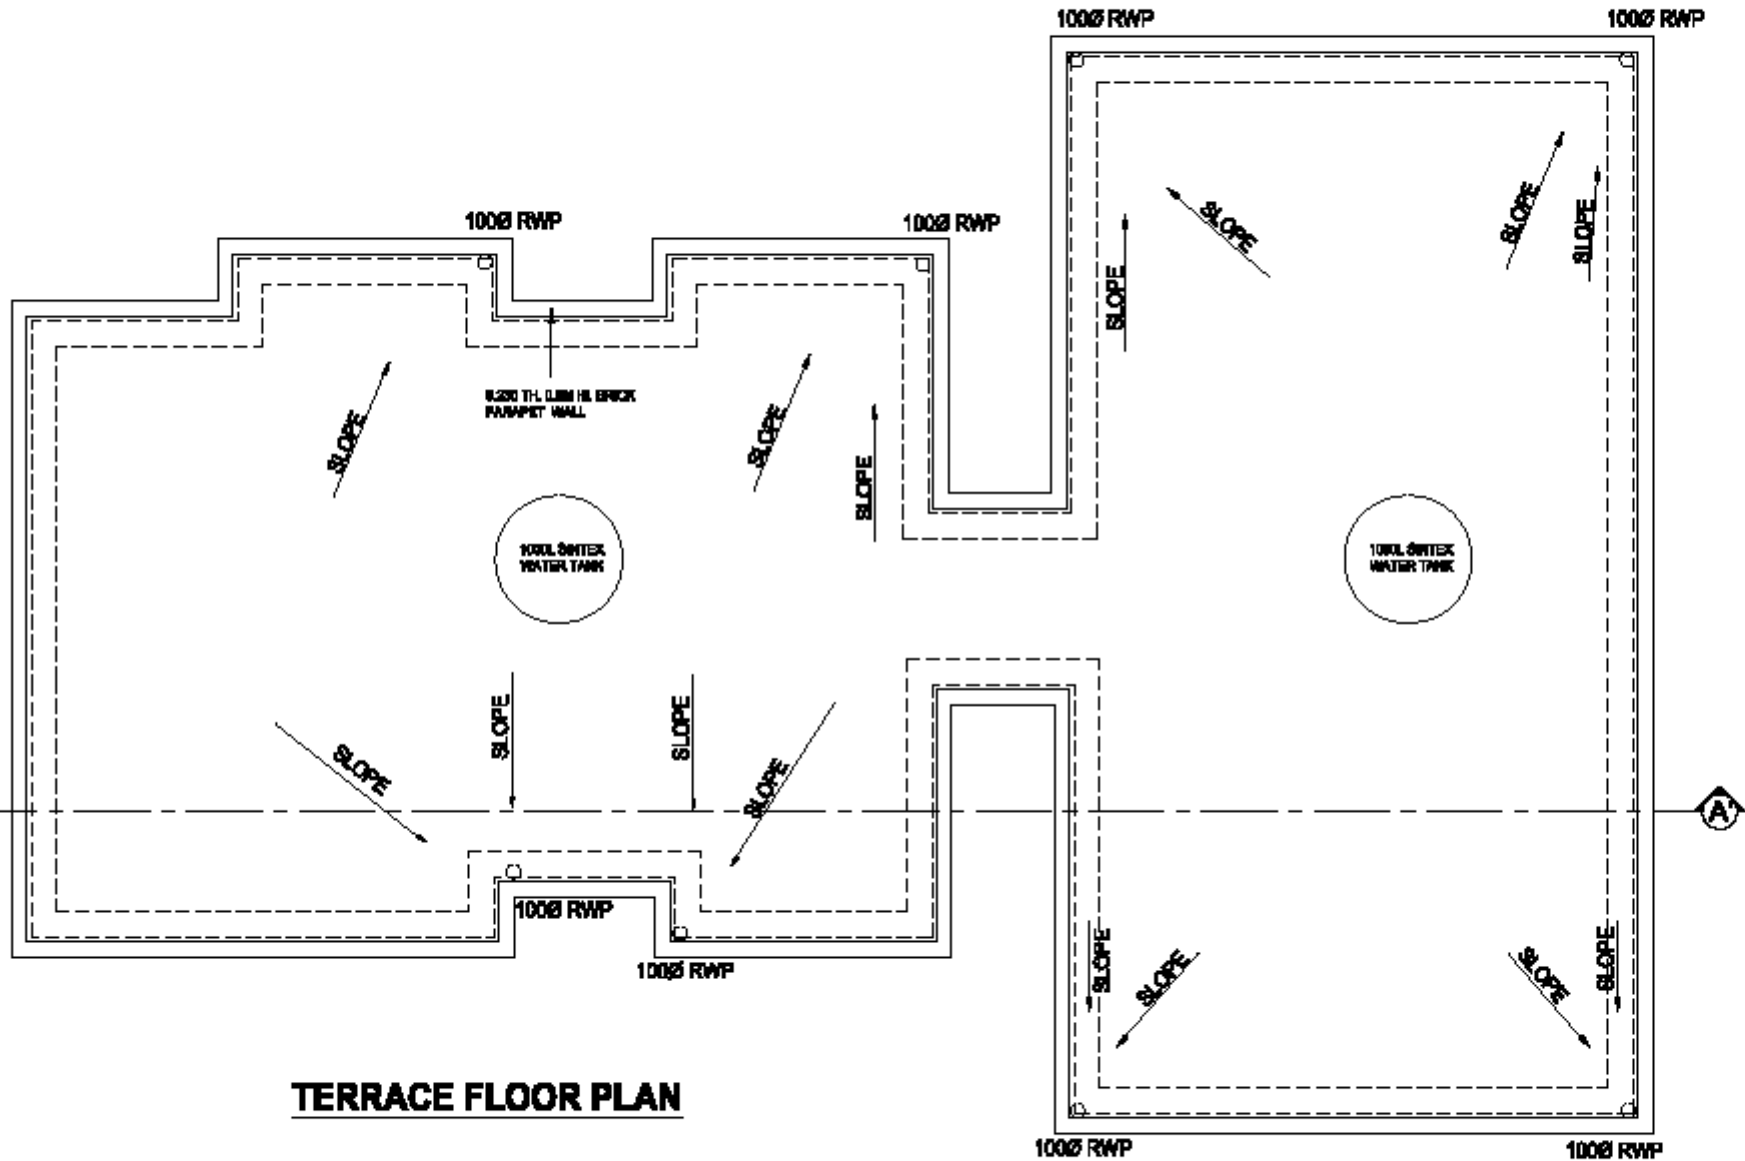

TERRACE FLOOR PLAN

AS BUILT DRAWING

NOTE :
 1. CONTRACTOR TO CHECK AND VERIFY ALL DIMENSIONS BEFORE EXECUTION OF THE WORK.
 2. PROVIDED DIMENSIONS SHALL BE FOLLOWED.
 3. ALL DIMENSIONS GIVEN ARE IN MILLIMETERS UNLESS OTHERWISE SPECIFIED.



EXISTING BUILDING	<input type="checkbox"/>
-------------------	--------------------------

CLIENT:
 TELANGANA STATE MEDICAL SERVICES AND INFRASTRUCTURE DEVELOPMENT CORPORATION

PROJECT TITLE:
 PREPARATION OF SURVEY MAP AND ASSET MAPPING FOR PHC AT JHARASANGAM(?) MEDAK DISTRICT

TITLE:
 EXISTING SURVEY LAYOUT PLAN OF PRIMARY HEALTH CENTER IN JHARASANGAMPALLE, JHARASANGAM MEDICAL, MEDAK DIST, TELANGANA STATE.

**PHC JHARASANGAM
 TERRACE FLOOR PLAN BLOCK A**


SCALE	1/100
DATE	JUN 2019
DRAWN	BY/WH
CHECKED	BY/WH

CONSULTANT :


S. KUMAR
 ARCHITECTS & ENGINEERS
 H.No. 9-9-7446, 1st Floor, ADRA Hospital Lane,
 Sitaram Nagar, Ramachandrapuram, Hyderabad - 500013.
 T. & P. No : 040-87822000 ; 040-88882000
 Email : s.kumar.architectsengineers@gmail.com
 web : http://s.kumar.architects.com/ksae

PROJECT NO. SK-JHA-PHC-A-02

NOTE :
 1. CONTRACTOR TO CHECK AND VERIFY ALL DIMENSIONS BEFORE EXECUTION OF THE WORK.
 2. PROVIDED DIMENSIONS SHALL BE FOLLOWED.
 3. ALL DIMENSIONS GIVEN ARE IN MILLIMETERS UNLESS OTHERWISE SPECIFIED.

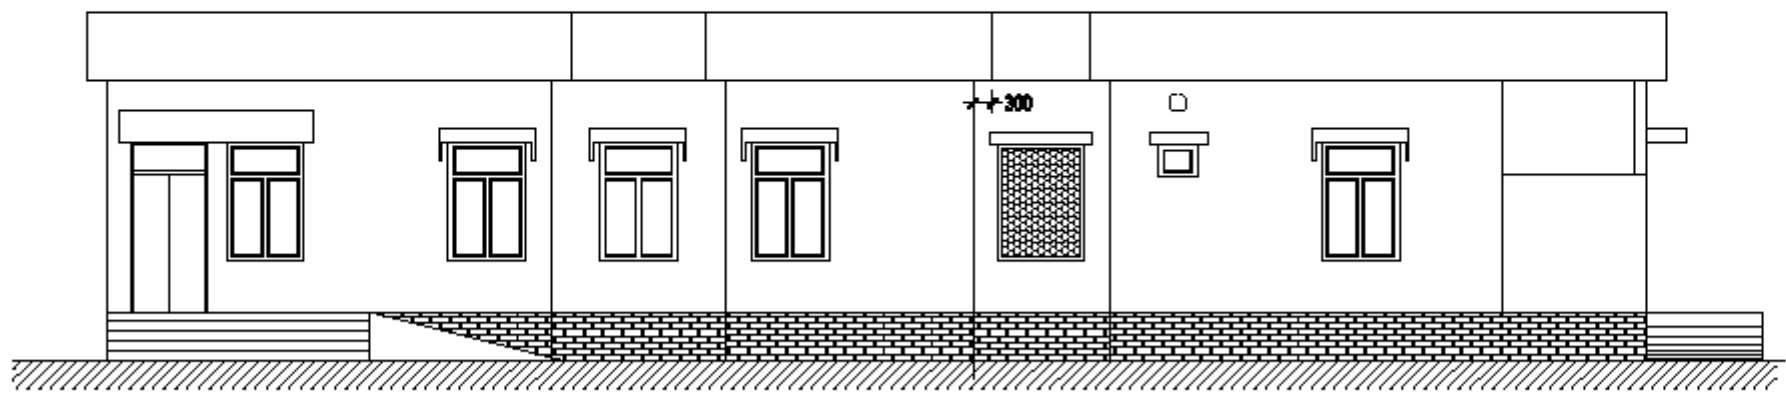

FRONT ELEVATION

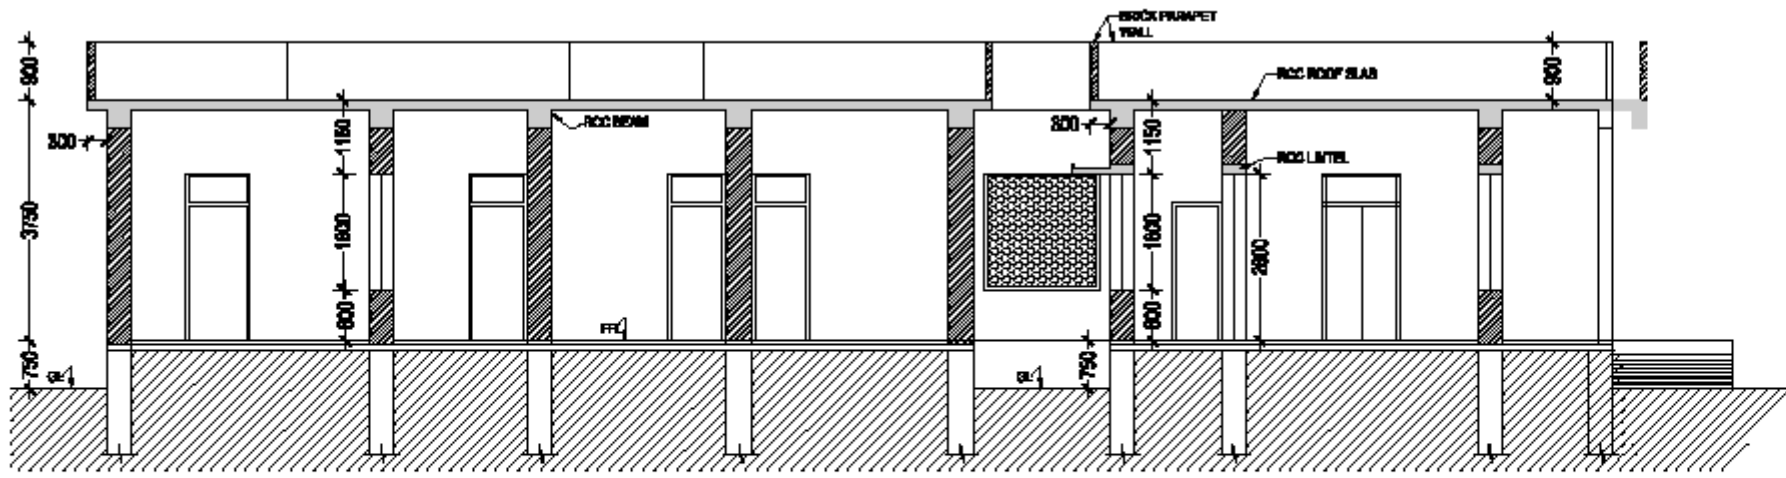

SECTION AT AA'

CLIENT:
 TELANGANA STATE MEDICAL SERVICES AND INFRASTRUCTURE DEVELOPMENT CORPORATION

PROJECT TITLE:
 PREPARATION OF SURVEY MAP AND AMBET MAPPING FOR PHC AT JHARASANDAM MEDAK DISTRICT

TITLE:
 CENTER SERVICE LAYOUT PLAN OF PHC AND HEALTH CENTER IN JHARASANDAM VILLAGE, JHARASANDAM SERIAL, MEDAK DIST, TELANGANA STATE.

PHC JHARASANDAM ELEVATION & SECTION BLDG. A	
SCALE	1/10
DATE	JUN 2019
DRAWN	MDR
CHECKED	YMR


CONSULTANT :

S. KUMAR
 ARCHITECTS & ENGINEERS
 H.No. 9-9-7446, 1st Floor, ADRA Hospital Lane,
 Sitaram Nagar, Ramachandrapuram, Hyderabad - 500113.
 T. & P. No. : 040-87624888; 9948888888
 Email : s.kumar.architectsengineers@gmail.com
 web : http://s.kumar.architects.com/ksae


AS BUILT DRAWING

DRG. NO. SK-JHA-PHC-A-03

NOTE :
 1. CONTRACTOR TO CHECK AND VERIFY ALL DIMENSIONS BEFORE EXECUTION OF THE WORK.
 2. PROVIDED DIMENSIONS SHALL BE FOLLOWED.
 3. ALL DIMENSIONS GIVEN ARE IN MILLIMETERS UNLESS OTHERWISE SPECIFIED.

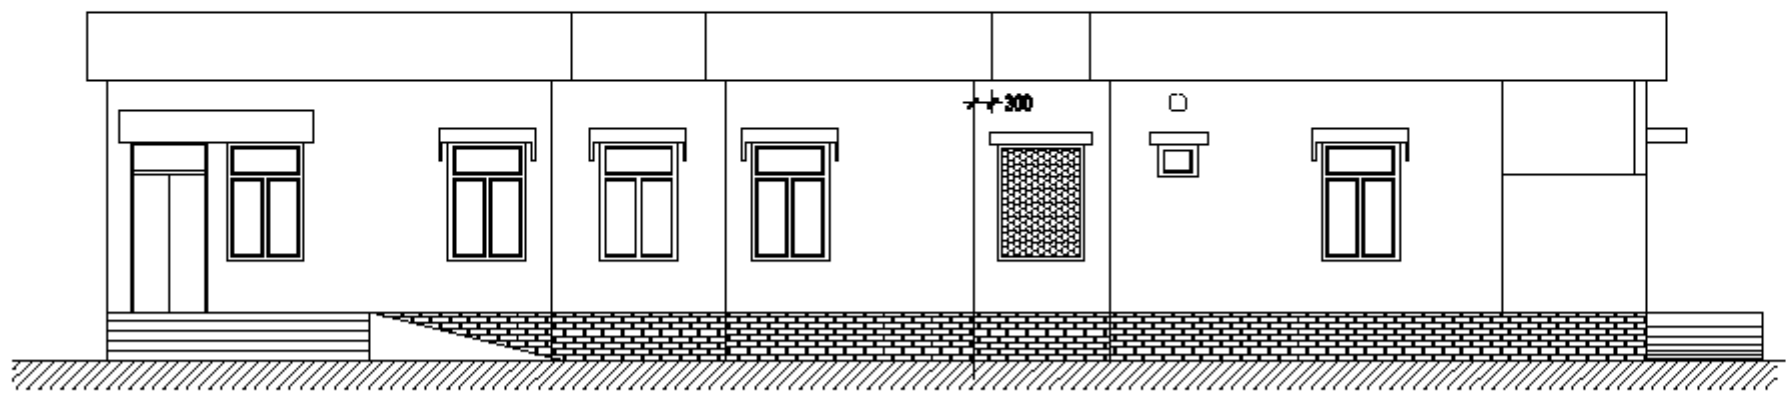

FRONT ELEVATION

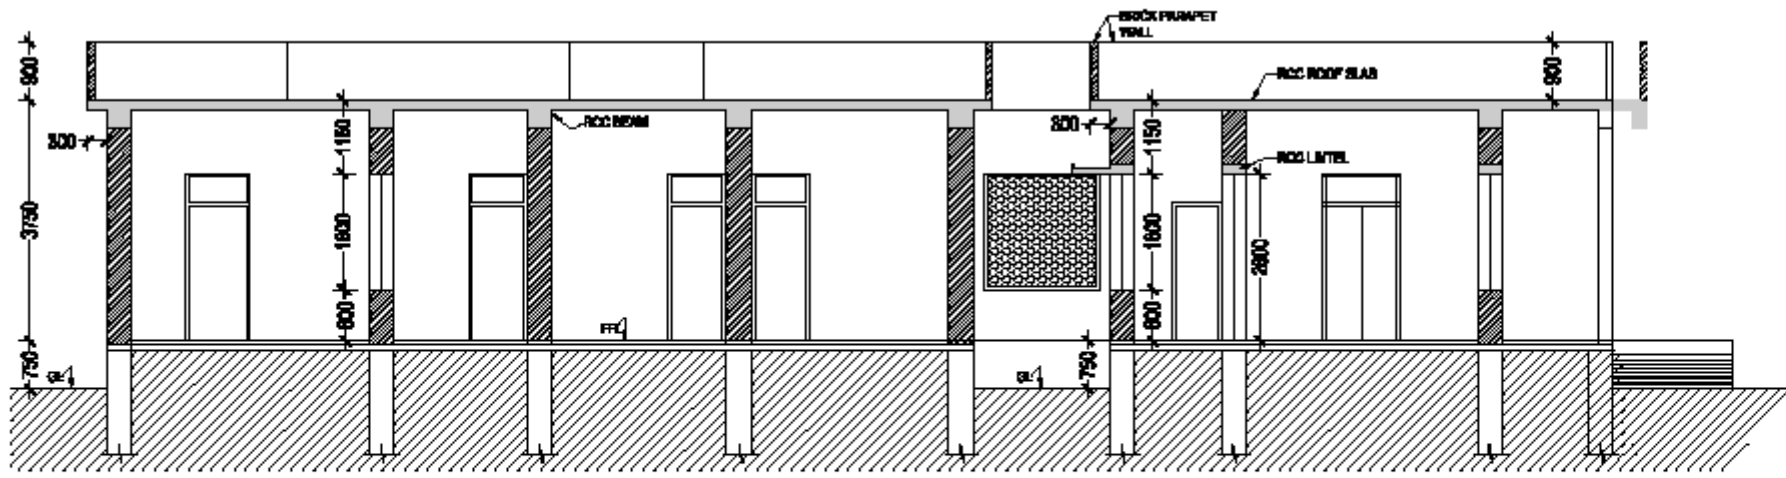

SECTION AT AA'

CLIENT:
 TELANGANA STATE MEDICAL SERVICES AND INFRASTRUCTURE DEVELOPMENT CORPORATION

PROJECT TITLE:
 PREPARATION OF SURVEY MAP AND AMBET MAPPING FOR PHC AT JHARASANDAM MEDAK DISTRICT

TITLE:
 CENTER SERVICE LAYOUT PLAN OF PHC AND HEALTH CENTER IN JHARASANDAM MEDAK DISTRICT, TELANGANA STATE.

PHC JHARASANDAM
 ELEVATION & SECTION BLDG. A

SCALE	1/10
DATE	JUN 2018
DRAWN	MDR
CHECKED	YMR


CONSULTANT:

S. KUMAR
 ARCHITECTS & ENGINEERS
 H.No. 9-9-7446, 1st Floor, ADRA Hospital Lane,
 Sitaram Nagar, Ramachandrapuram, Hyderabad - 500113.
 T. & P. No. : 040-87624888; 9948888888
 Email : s.kumar.architectsengineers@gmail.com
 web : http://s.kumar.architects.com/ksae

AS BUILT DRAWING

SK-JHA-PHC-A-03

EXISTING SURVEY LAYOUT PLAN OF PHC HOSPITAL IN JARASAGAM VILLAGE, JARASAGAM MANDAL, MEDAK DIST, TELANGANA STATE.

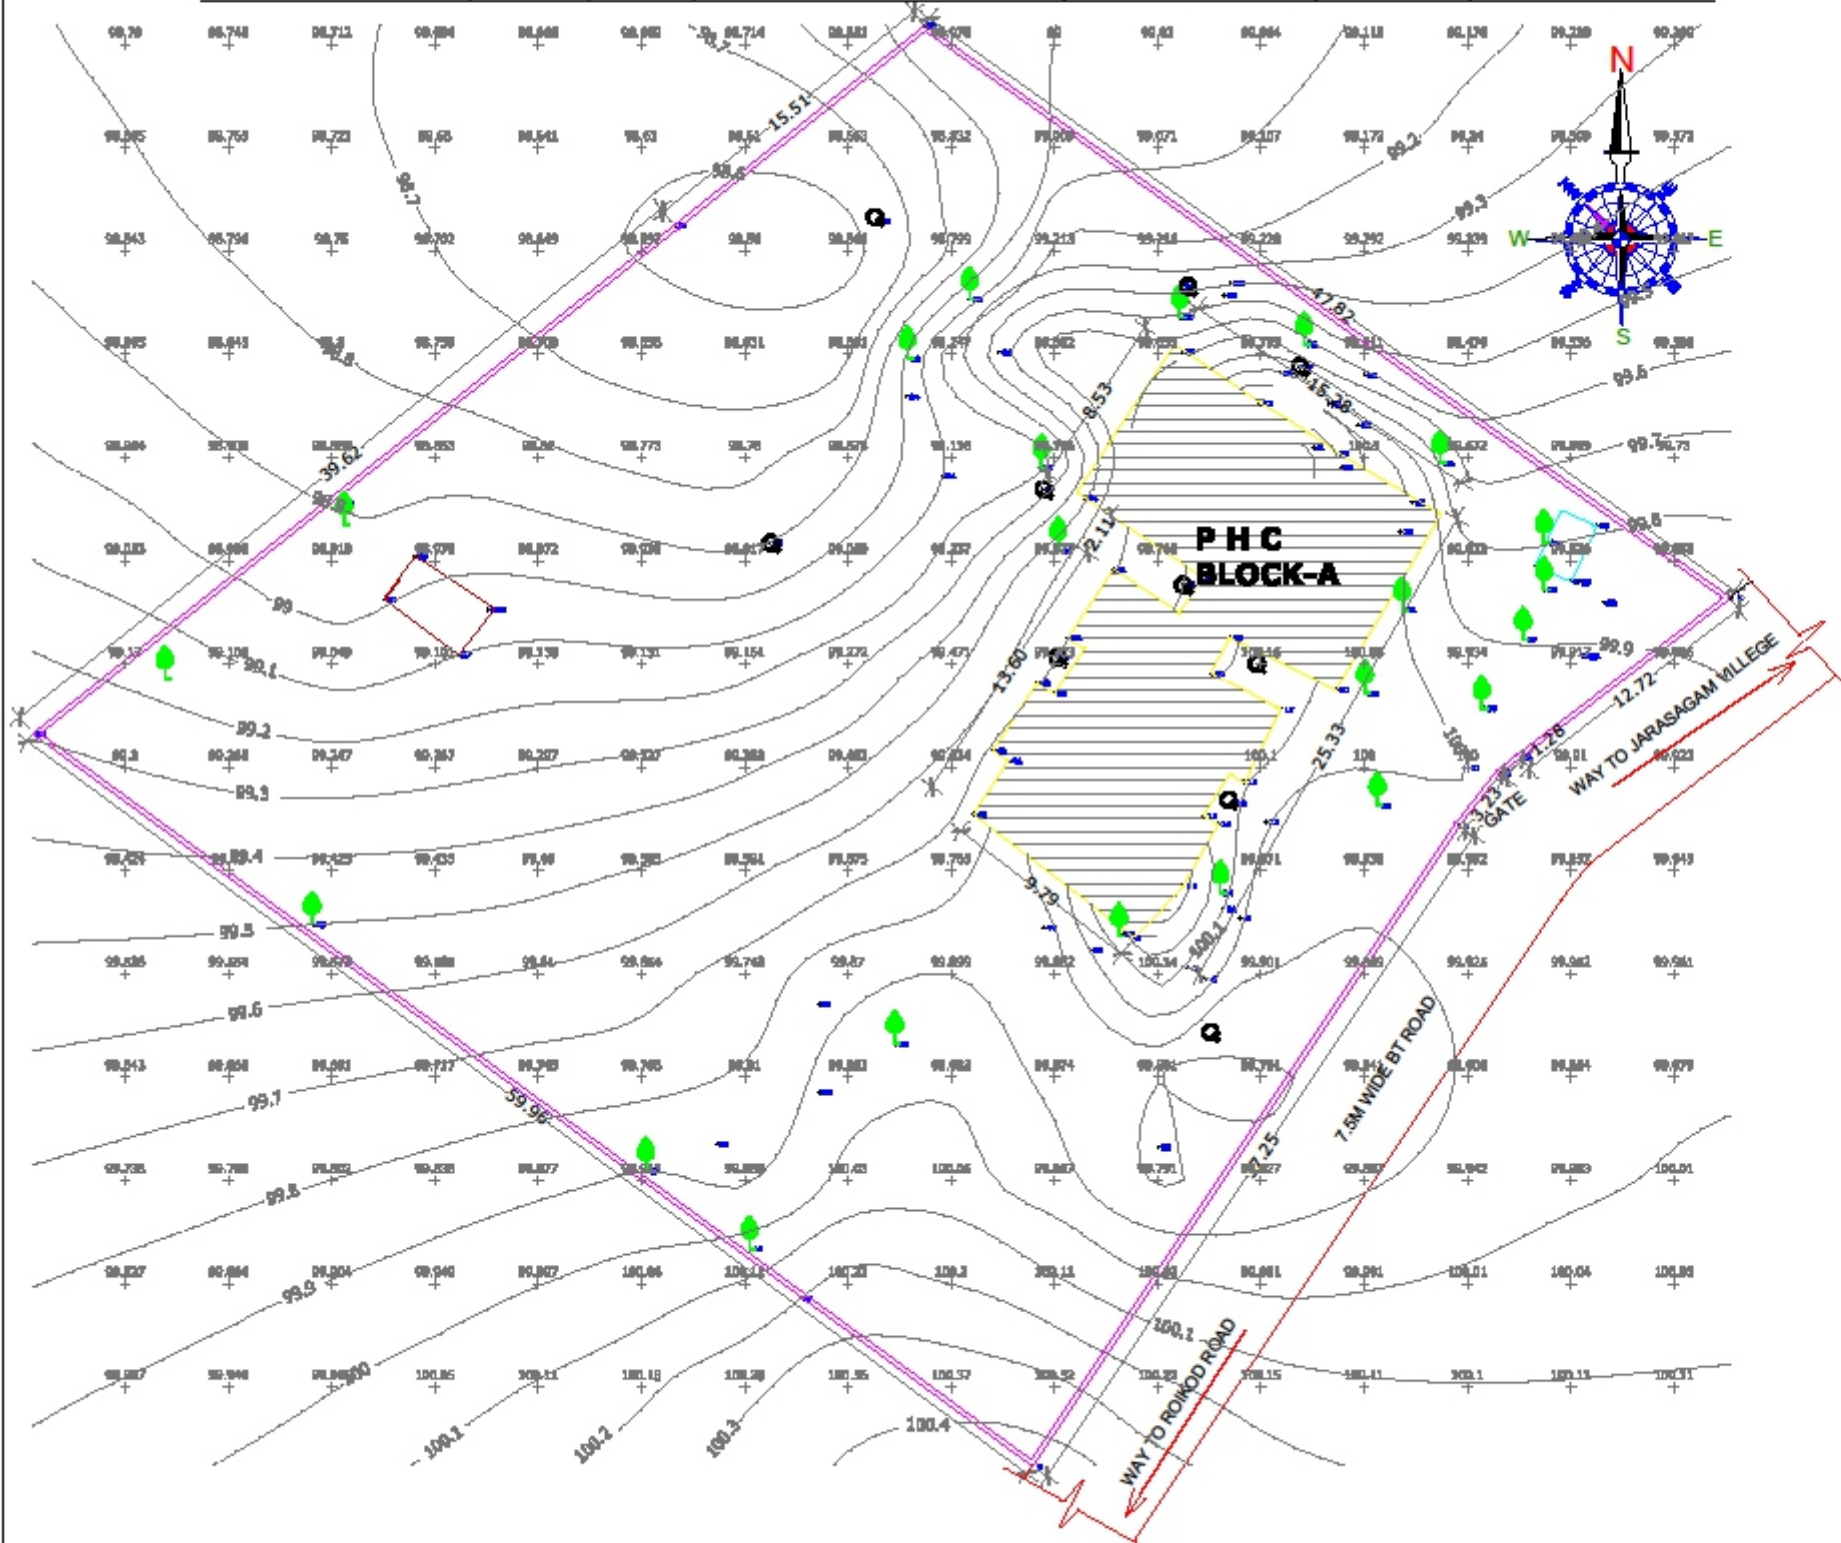

- NOTE :**
1. CONTRACTOR TO CHECK AND VERIFY ALL DIMENSIONS BEFORE EXECUTION OF THE WORK.
 2. FIGURED DIMENSIONS SHALL BE FOLLOWED.
 3. ALL DIMENSIONS GIVEN ARE IN MILLIMETERS UNLESS OTHERWISE SPECIFIED.



LEGEND

ROAD	
BOUNDARY LINE	
MAN HOLE	MH
BORE WELL	BORE
ELECTRIC POLE	EP
TREE	
NEEM TREE	

AREA STATEMENT:-
 SITE AREA = 1.86 ACRES, 8794.198 SQ M
 EXISTING PHC JHARABANGAM
 GROUND FLOOR BUILT UP AREA = 3000 SQ M

CLIENT
 TELANGANA STATE MEDICAL SERVICES AND
 INFRASTRUCTURE DEVELOPMENT
 CORPORATION

PROJECT TITLE
 REPLICATION OF SURVEY MAP AND ASSET MAPPING FOR PHC
 AT JARASAGAM (V) MEDAK DISTRICT

TITLE
 EXISTING SURVEY LAYOUT PLAN OF PHC
 HOSPITAL IN JARASAGAM VILLAGE, JARASAGAM
 MANDAL, MEDAK DIST, TELANGANA STATE.

PHC JHARABANGAM
 EXISTING SITE PLAN

SCALE	NTS
DATE	JUNE 2018
DRAWN	SANDEEP
CHECKED	VINAY

CONSULTANT

S. KUMAR
 ARCHITECTS & ENGINEERS
 H.No: 8-9-74/5, 1st Floor, Aditya Hospital Lane,
 Brahmacharya, Jhansipuram, Hyderabad - 500032.
 T.S. No. RD - 104-2-7328889; +91 9848303030
 Email: skumar_sandeeprajeeva@gmail.com
 web: http://www.skumararchitects.com/

DRAWN
SK-JAR-PHC-LP-01