


GROUND FLOOR PLAN

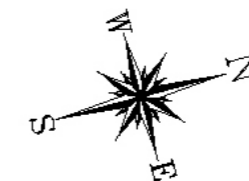


JOINERY DETAILS:-

| | |
|------------------|-------------------|
| Doors :- | Windows :- |
| MD :- 1.20 x 2.1 | W :- 1.45 x 1.65 |
| D :- 1.20 x 2.1 | W1 :- 1.80 x 1.65 |
| D1 :- 0.91 x 2.1 | W2 :- 1.20 x 1.65 |
| D2 :- 0.75 x 2.1 | V :- 0.60 x 0.45 |

AREA STATEMENT :-
Built Up Area :- 276.95 Sqm

| | |
|--|--------------------------|
| PROJECT TITLE | |
| SURVEY PLAN OF PHC PEDDAVOORA SITUATED AT PEDDAVOORA, NALGONDA DIST. | |
| DEALT BY | |
| MAPE CONNOISSEURS 3-4-485/1/D1, 1 FLOOR, Near Bank Of Baroda, OPP. Reddy Women's College, BARKATPURA, HYDERABAD-27. TEL. NO. : 27566409 FAX. NO. : 27566691 E-MAIL : mapehyd1@gmail.com | |
| DRG. TITLE | |
| AS BUILT DRAWING | |
| DRAWN BY : | DATE : 16-06-2016 |
| JAGDISH | |
| DRG. NO. | |
| TSMSIDC / PHC HOSPITAL / PEDDAVOORA /AR-02 | |

Executive Engineer,
TSMSIDC,
NALGAONDA DIST.

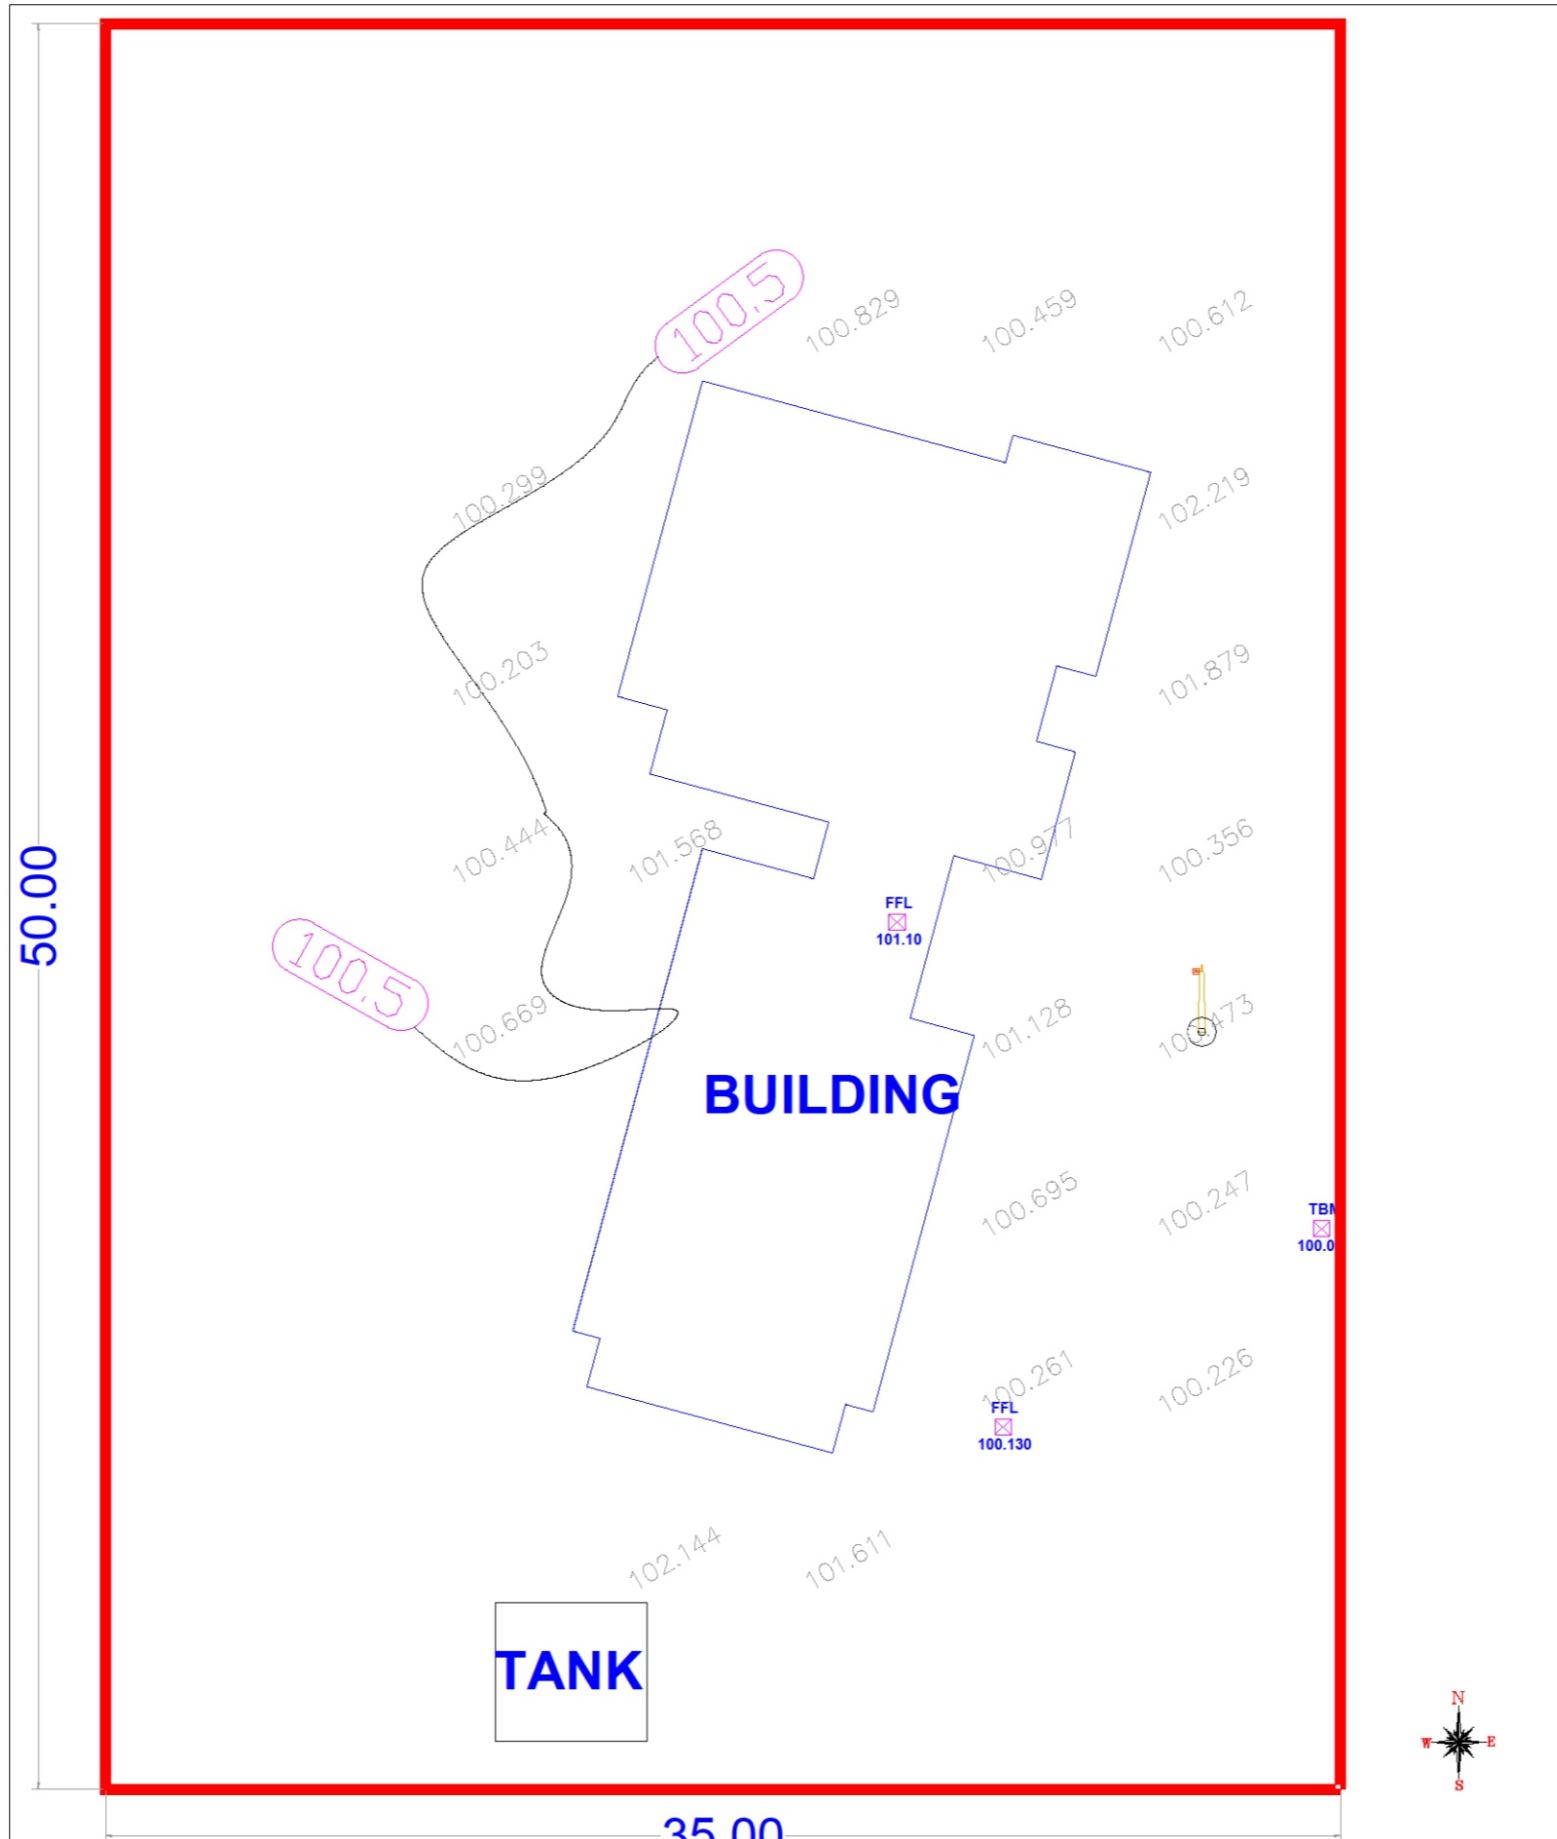

- Legend :-**
- Boundary
 - Roads
 - Buildings
 - Septic Tanks
 - TBM & FFL
 - Trees
 - Manholes
 - Bore
 - Ele. Pole
 - Flag Pole
 - Tap

AREA STATEMENT :-
 Total Site Area :- Sqm
 Surveyed Area :- 1.750 Sqm
 Note:- No Separate Boundary, There are Other Govt. Offices Like M.R.O. Office, M.D.O. Office etc., in the same premises.

PROJECT TITLE
SURVEY PLAN OF PHC PEDDAVOORA, SITUATED AT PEDDAVOORA, NALGONDA DIST.

| | |
|---------------------|---|
| DRAWN BY JAGDESH | CHECKED BY PANKAJ MEHENDALE (STRUCTURAL CONSULTANT) |
| DATE : 02-05-2016 | |

Executive Engineer,
 TMSIDC,
 NALGAONDA DIST.