



COPY RIGHT OF THIS DRAWING BELONGS TO M/S S.S. CONSULTANTS AND SHOULD NOT BE USED FOR ANY PURPOSE OTHER THAN SPECIFIED WITHOUT PRIOR PERMISSION.

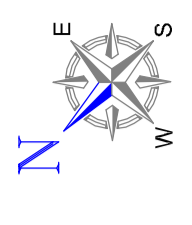

**KEY PLAN**

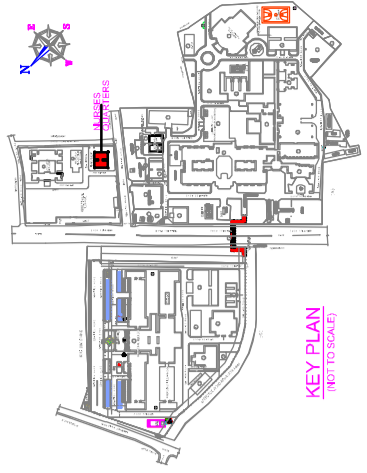

**APPROVED**  
 ADI-DI : 29-12-2015  
 CHIEF ENGINEER (TMS/SDC)  
 HYDERABAD

NON-TEACHING AREAS :

FLOORS	AREA IN SLABS	No. of Urine per Floor	Fifth area of each Urine Slabs
STILT	288.45	PARKING	-
F.F	288.45	4	54.79
S.F	288.45	4	54.79
T.F	288.45	4	54.79
4th F	288.45	4	54.79
5th F	288.45	4	54.79
TOTAL	1819.70	20	

STATUS :  
 ARCHITECTURAL WORKING DRAWING

PROJECT :  
 CONSTRUCTION OF NEW MEDICAL COLLEGE  
 WITH ULTRA MODERN FACILITIES AT  
 NIZAMABAD IN NIZAMABAD DIST.

TITLE :  
 NURSES QUARTERS  
 STILT+5 FLOORS  
 TYPICAL & TERRACE FLOOR PLANS


CLIENT :  
 TELANGANA STATE MEDICAL SERVICES &  
 INFRASTRUCTURE DEVELOPMENT  
 CORPORATION  
 DW & HS CAMPUS  
 SULTAN SAHEB KOTI, HYDERABAD,  
 TELANGANA - 500088.

CONSULTANTS :  
**S.S. CONSULTANTS**  
 PROJECT CONSULTANTS  
 #17A5, JABBAR BUILDINGS,  
 BEGUNPET, HYDERABAD-16  
 PH: 6510240, 6510984.  
 FAX NO: 040-6537248.  
 email: sscs2007@gmail.com


DATE : 17/10/15  
 SCALE : 1:100  
 DEALT BY : S.Parameshwari  
 ARCHITECT : N.V.SRINIVAS RAO  
 CHECKED BY : S.S.RAO

SHEET NO :  
**01**


DRG.NO : SS/APHM/DC/ NZB/ Nurses Qtrs./ PLANS / AR-0

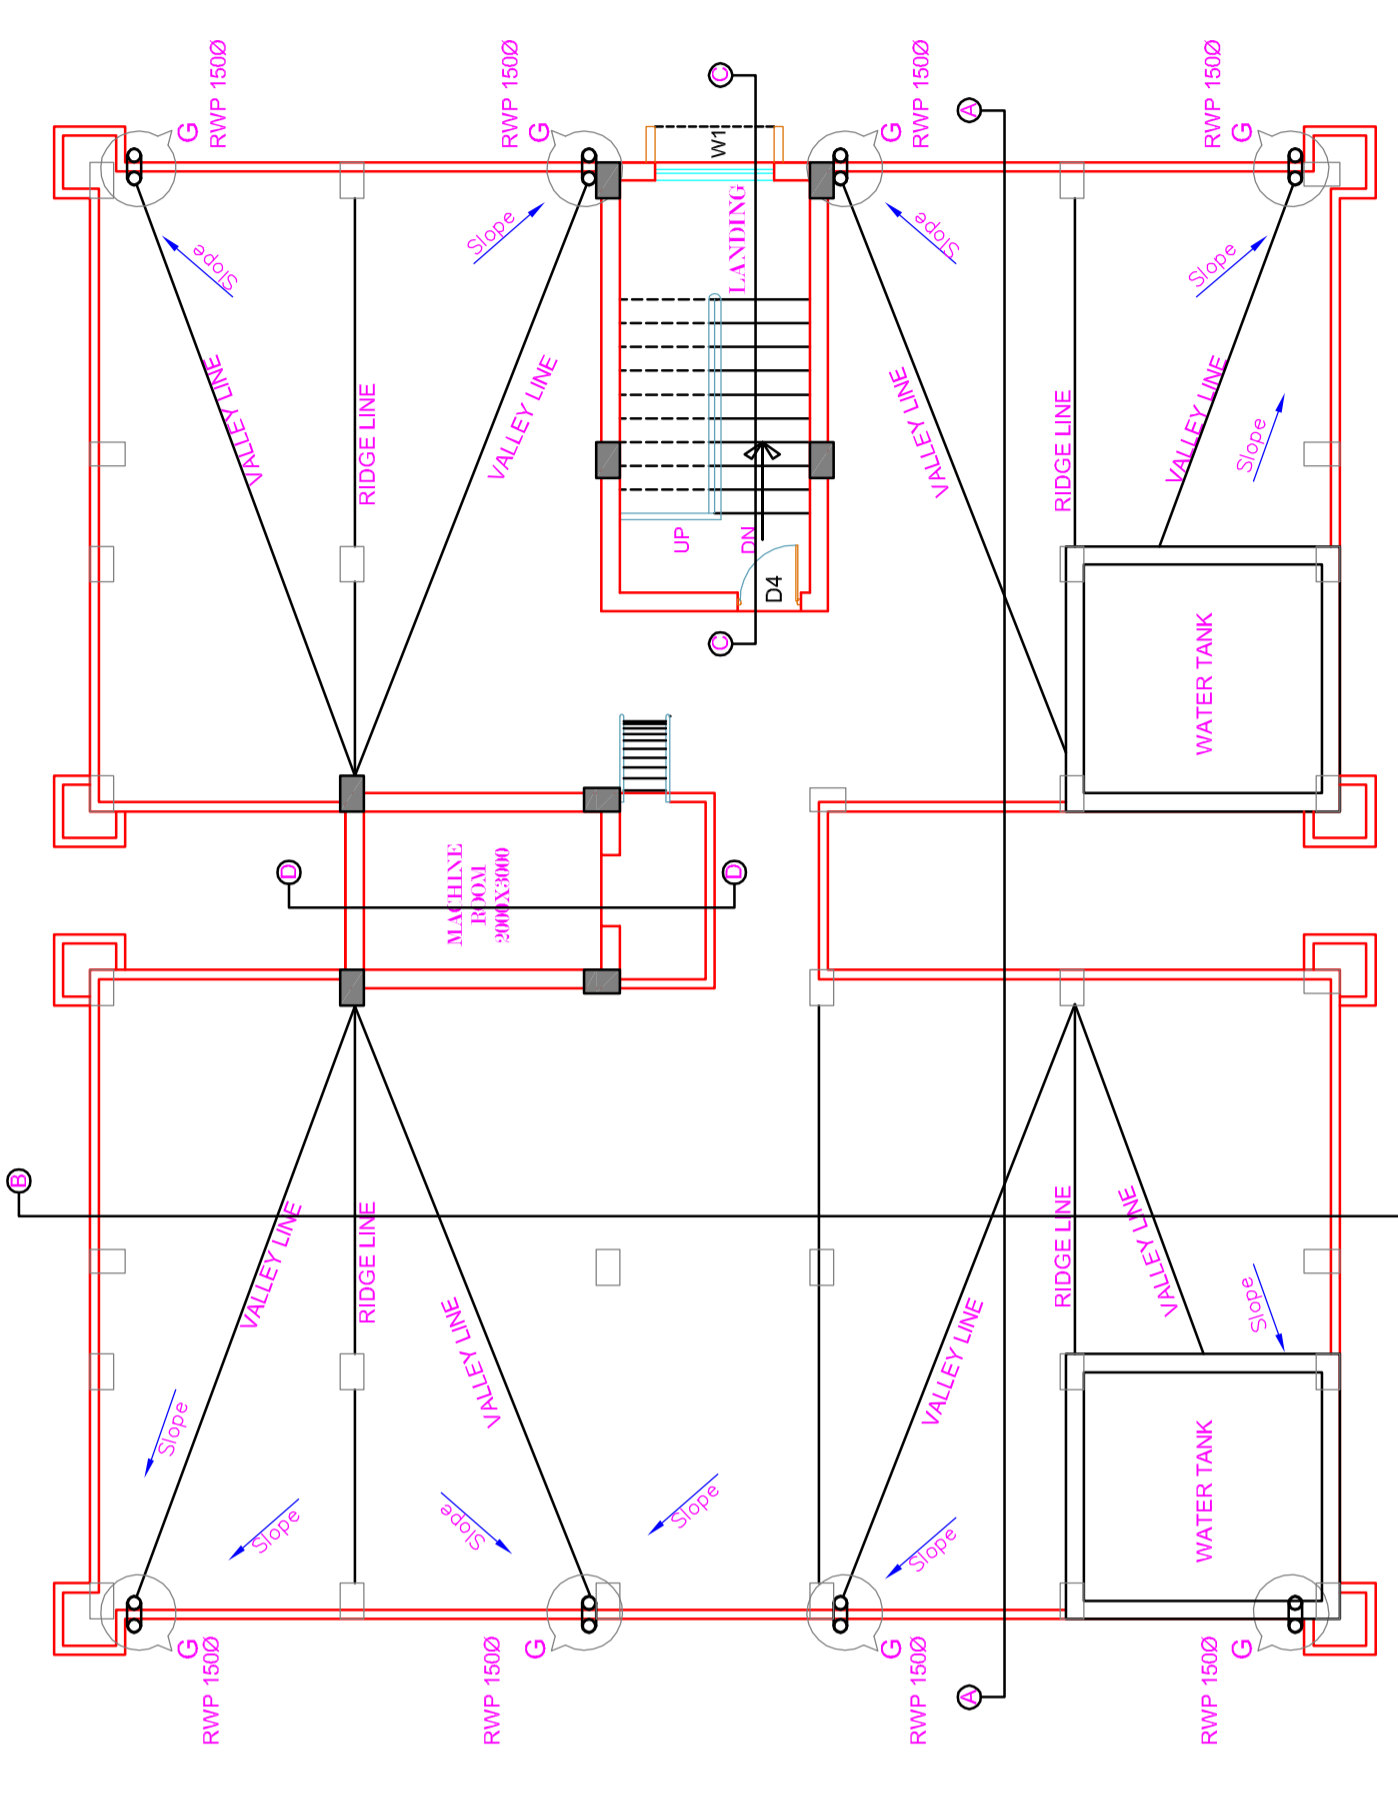


**TERRACE PLAN**

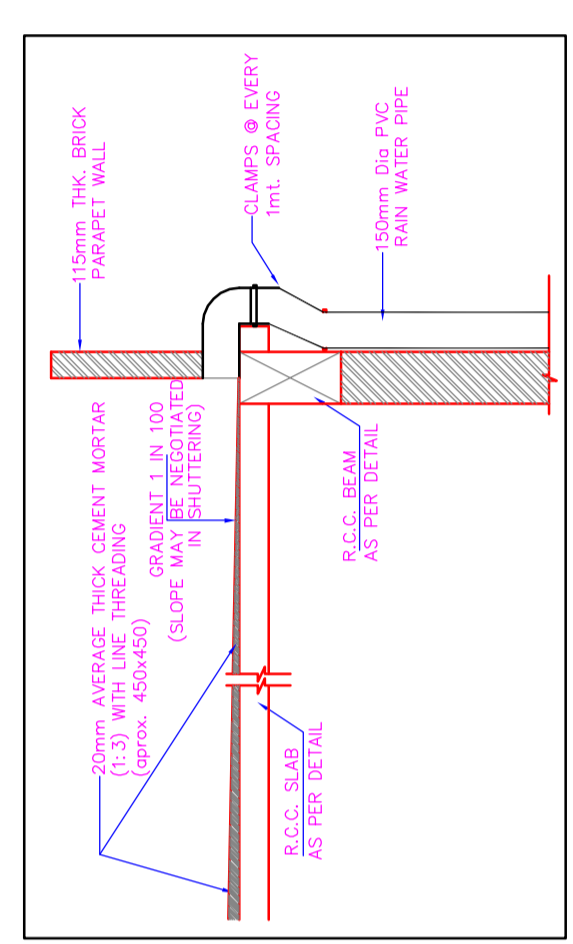

**TYPICAL RAIN WATER DOWN TAKE  
 PIPE FIXING DETAILS AT 'G'**  
 SCALE - NTS

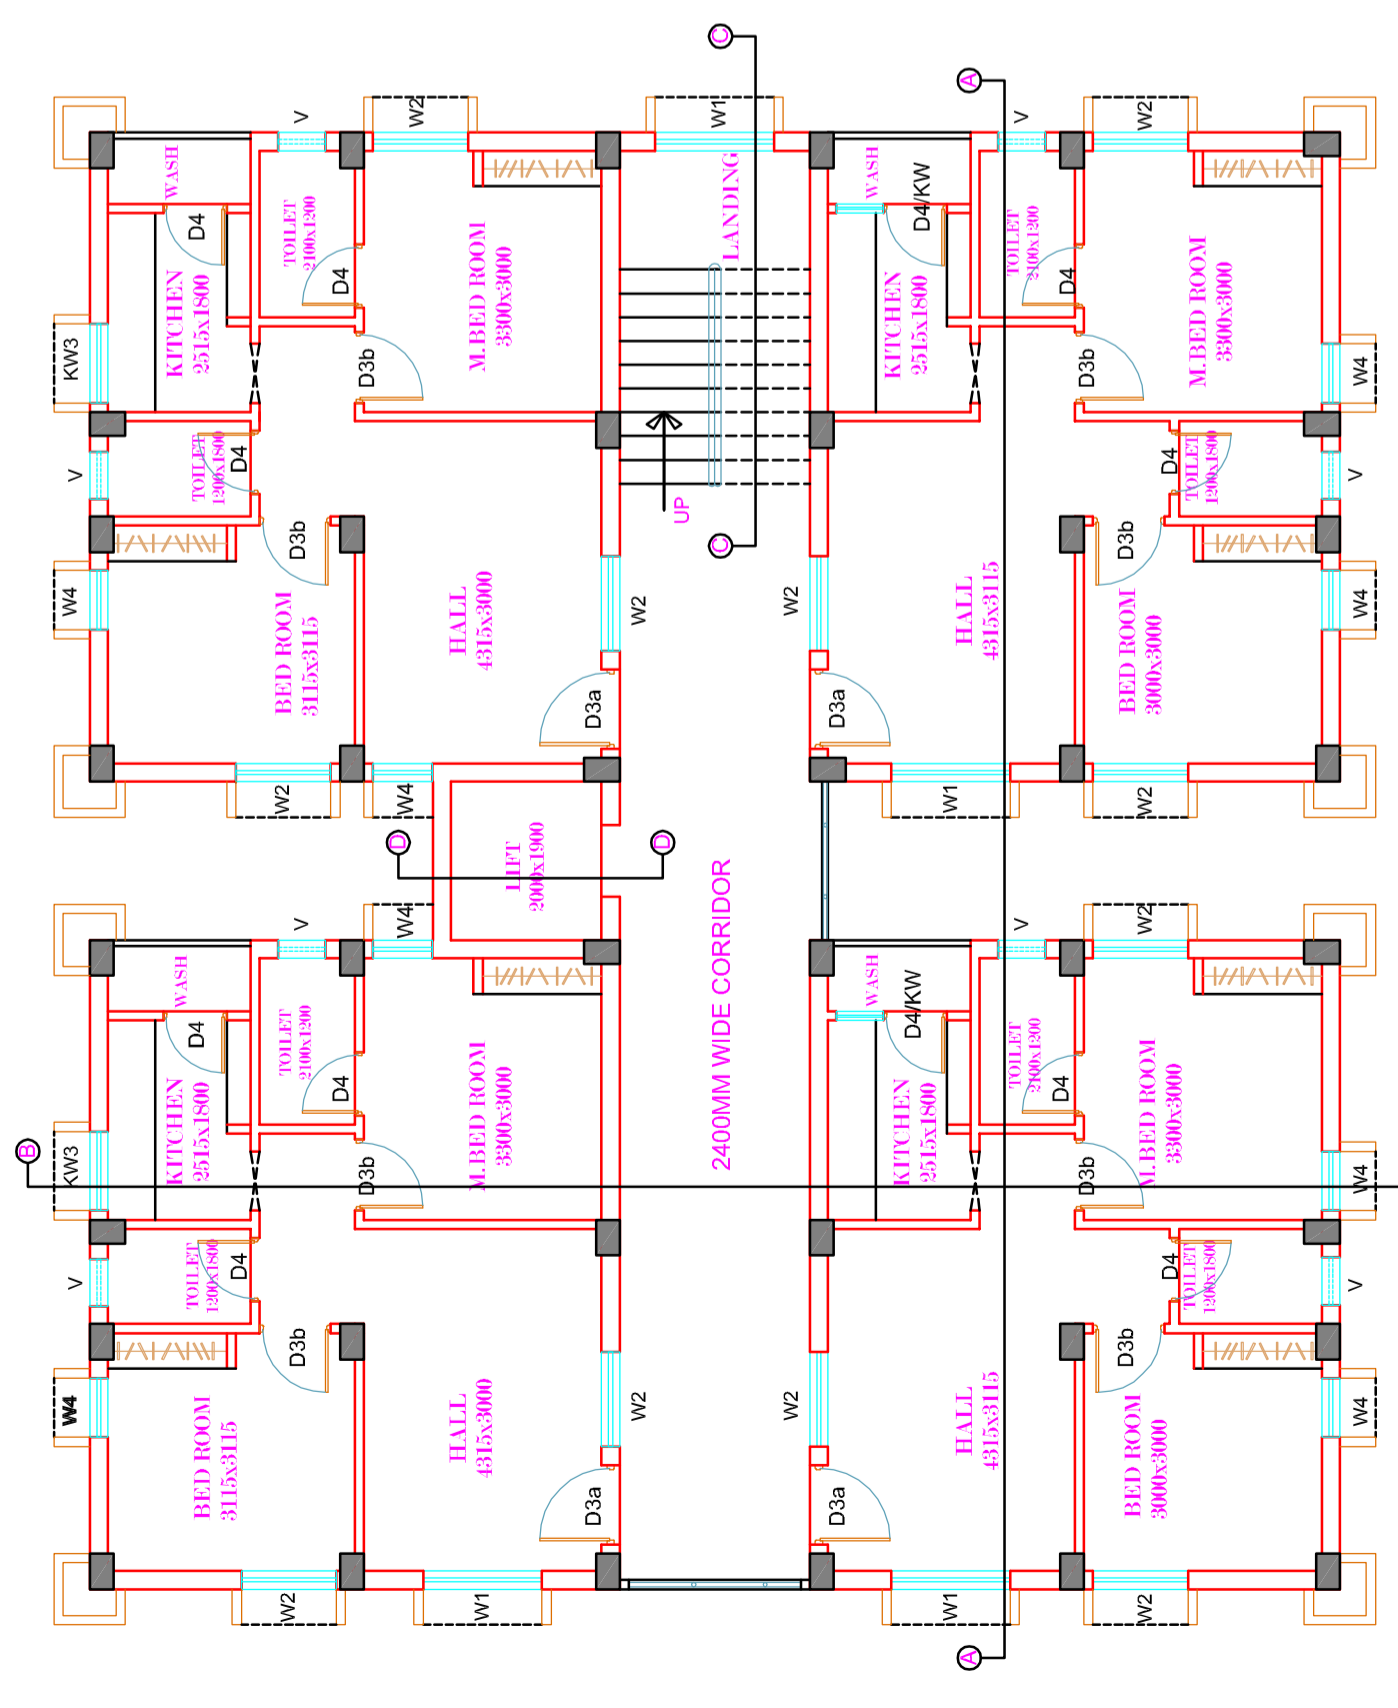

**TYPICAL WORKING PLAN**

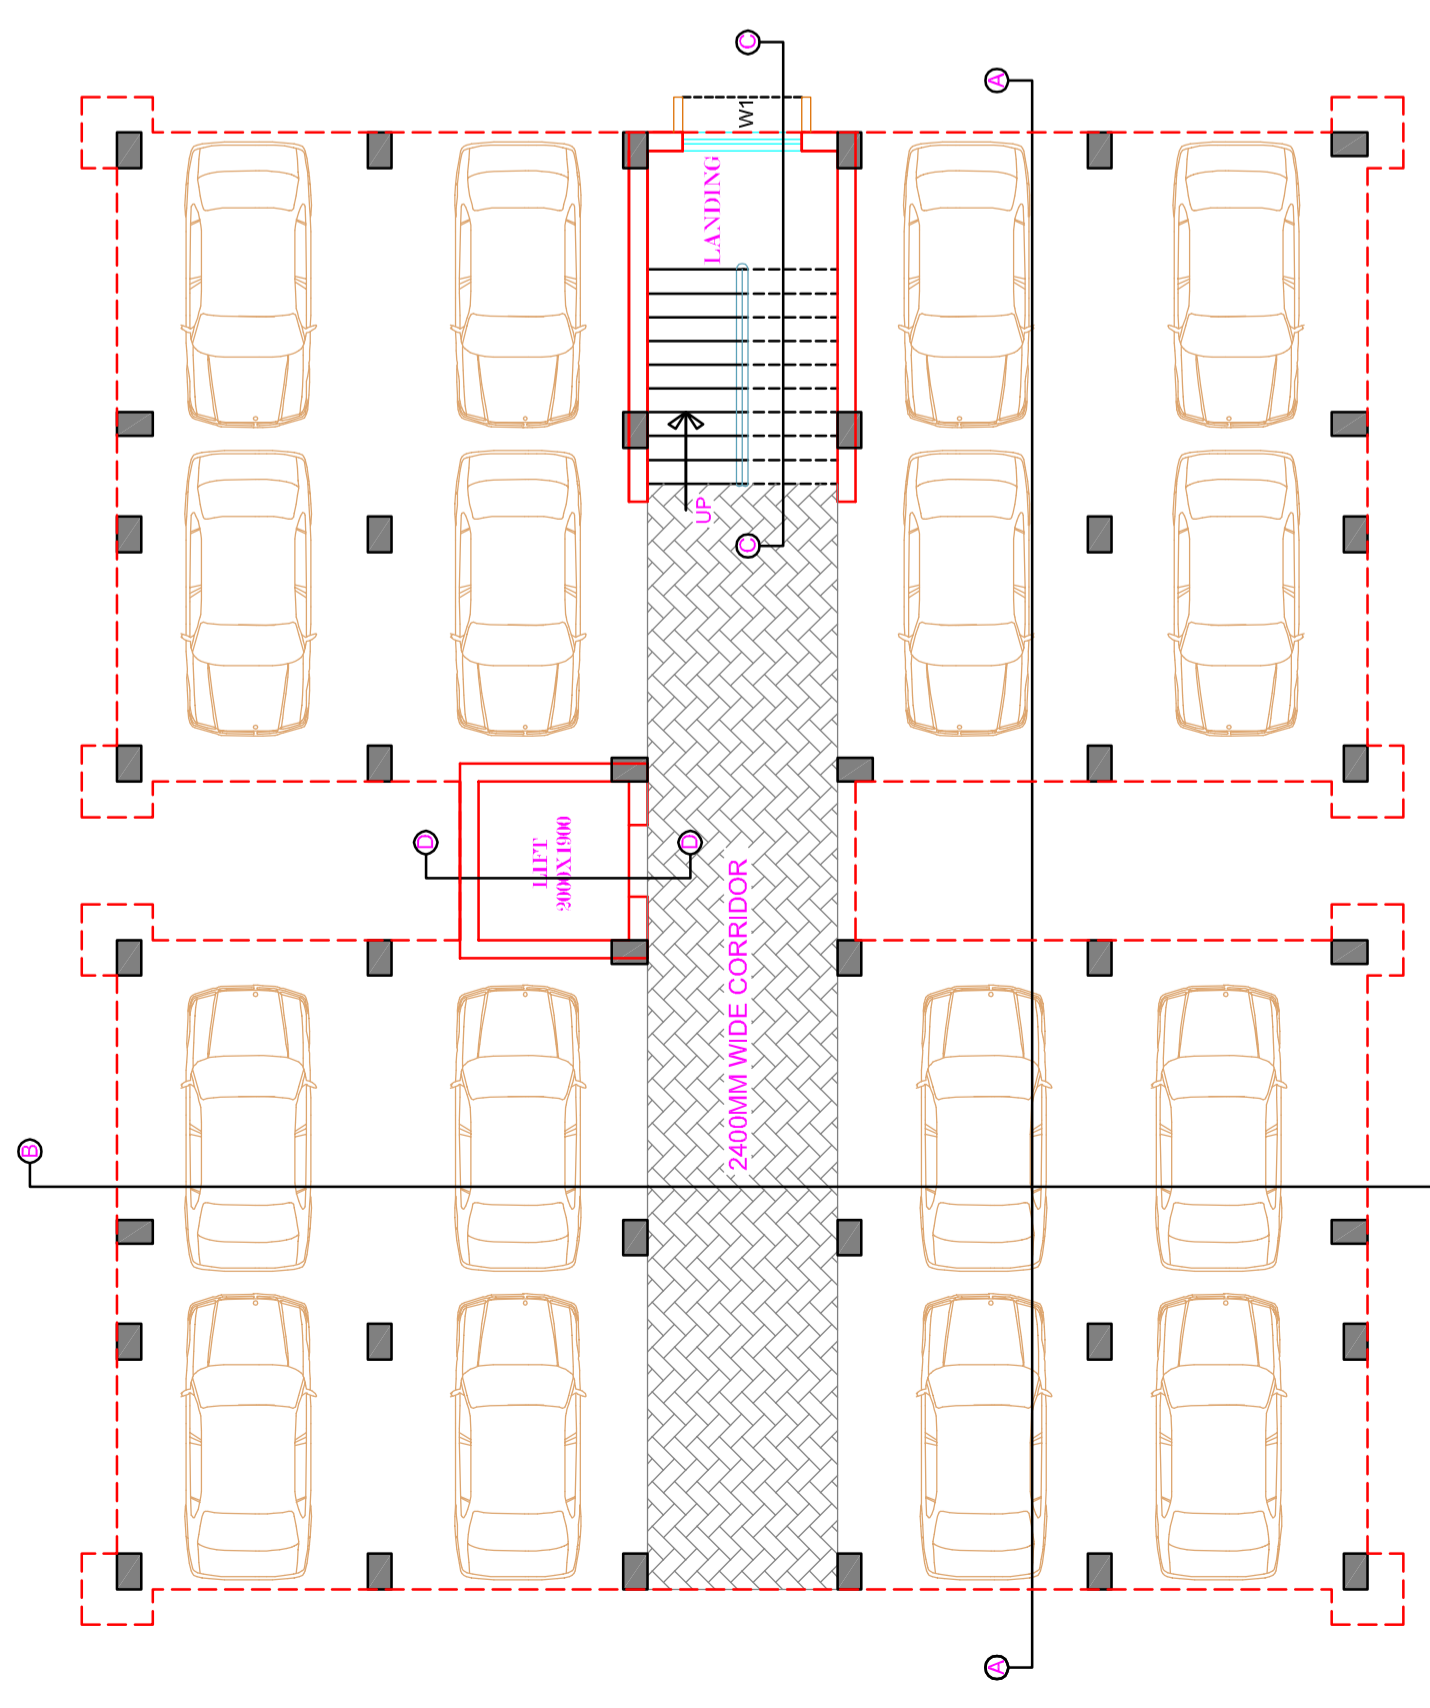

**STILT FLOOR PLAN**

**JOINERY SCHEDULE**

NAME	SIZE	S.F.	1st	2nd	3rd	4th	5th	T.F.
WOODEN DOOR	1000x2100	-	4	4	4	4	4	-
WOODEN DOOR	900x2100	-	8	8	8	8	8	-
WOODEN DOOR	800x2100	-	10	10	10	10	10	-
WOODEN DOOR	600x2100	-	2	2	2	2	2	-
WOODEN DOOR	300x500	-	4	4	4	4	4	-
PRE PAINTED STEEL WINDOW	1500x1300	-	11	11	11	11	11	-
PRE PAINTED STEEL WINDOW	1200x1300	-	8	8	8	8	8	-
PRE PAINTED STEEL WINDOW	750x1300	-	2	2	2	2	2	-
PRE PAINTED STEEL WINDOW	1000x900	-	8	8	8	8	8	-
PRE PAINTED STEEL WINDOW	600x600	-	8	8	8	8	8	-